



JACK IN THE BOX #5499
5133 E Washington Blvd Commerce, CA 90040 USA

Revisions:
R2: Moved D3 to rear elevation, changed to red channel letters. 7/7/25-JMc

PERMIT



4444 Federal Blvd San Diego, CA 92102
(619) 527-6100 signtech.com

JACK IN THE BOX

J5499
5133 E Washington Blvd, Commerce, CA 90040 USA


This design is the exclusive property of Signtech and cannot be reproduced in whole or in part, without their prior written approval

Sales: Bob McCarter
Project Manager: Steve Wood
Design: JMc
Engineering:

date: 7/1/25
drawing: J5499 Permit Package
revision: R1-7/8/25-JMc
project ID: JIB_5499_1

SIGN LEGEND

SIGN #	DESCRIPTION	SIGN TYPE	SF	QTY
A	J67 PYLON SIGN	JITB2-PYL-J67-106x95-300	66.4	1
B1-B2	READER BOARD CABINET	JITB-RB-36x96	24.0	2
C1	READER BOARD FACE	JITB-RF-RB-35X95-TACOS	N/A	1
C2	READER BOARD FACE	JITB-RF-RB-35X95-BREAKFAST ALL DAY	N/A	1
D1-D2	J30 WALL SIGN	JITB2-J30	26.64	2
D3	J30 WALL SIGN - RED LETTERS	JITB2-J30-R	26.64	1
E1-E3	POSTER MARQUEE - SINGLE	JITB-WC-60x49-MARQUEE	20.5	1
F	ILLUM. ADDRESS CABINET	JITB-WC-16x42-ADDRESS-5133	4.67	1
G	OPEN LATE NIGHT WALL SIGN	JITB2-CL-44-OLN-H	58.76	1
I	PREVIEW MENU	JITB2-MB-47x88-PREVIEW	27.22	1
J	SPEAKER MENU	JITB2-MB-47x88-SPEAKER	28.07	1
K	SPEAKER MENU CANOPY	JITB2-CAN-70X86X121-P	N/A	2
L1-L2	DIR. SIGN - "ENTER"	JITB-DIR-17x17x48-ENTER-LEFT/RIGHT	2.3	1
L3	DIR. SIGN - "TY/DNE"	JITB-DIR-17x17x48-THANKYOU/DONOTENTER	2.3	1
M	HEIGHT DETECTOR	JITB2-H-BAR-120-FC0-5	N/A	2
N1-N2	BREAKFAST MENU EXTENDER	JITB2-MB-EXT-50x14-BREAKFAST	N/A	1
N3	LATE NIGHT MENU EXTENDER	JITB2-MB-EXT-50x14-LATE NIGHT	N/A	1
P	MENU LUG-ON HARDWARE	JITB-MB-PNL-15x30	N/A	

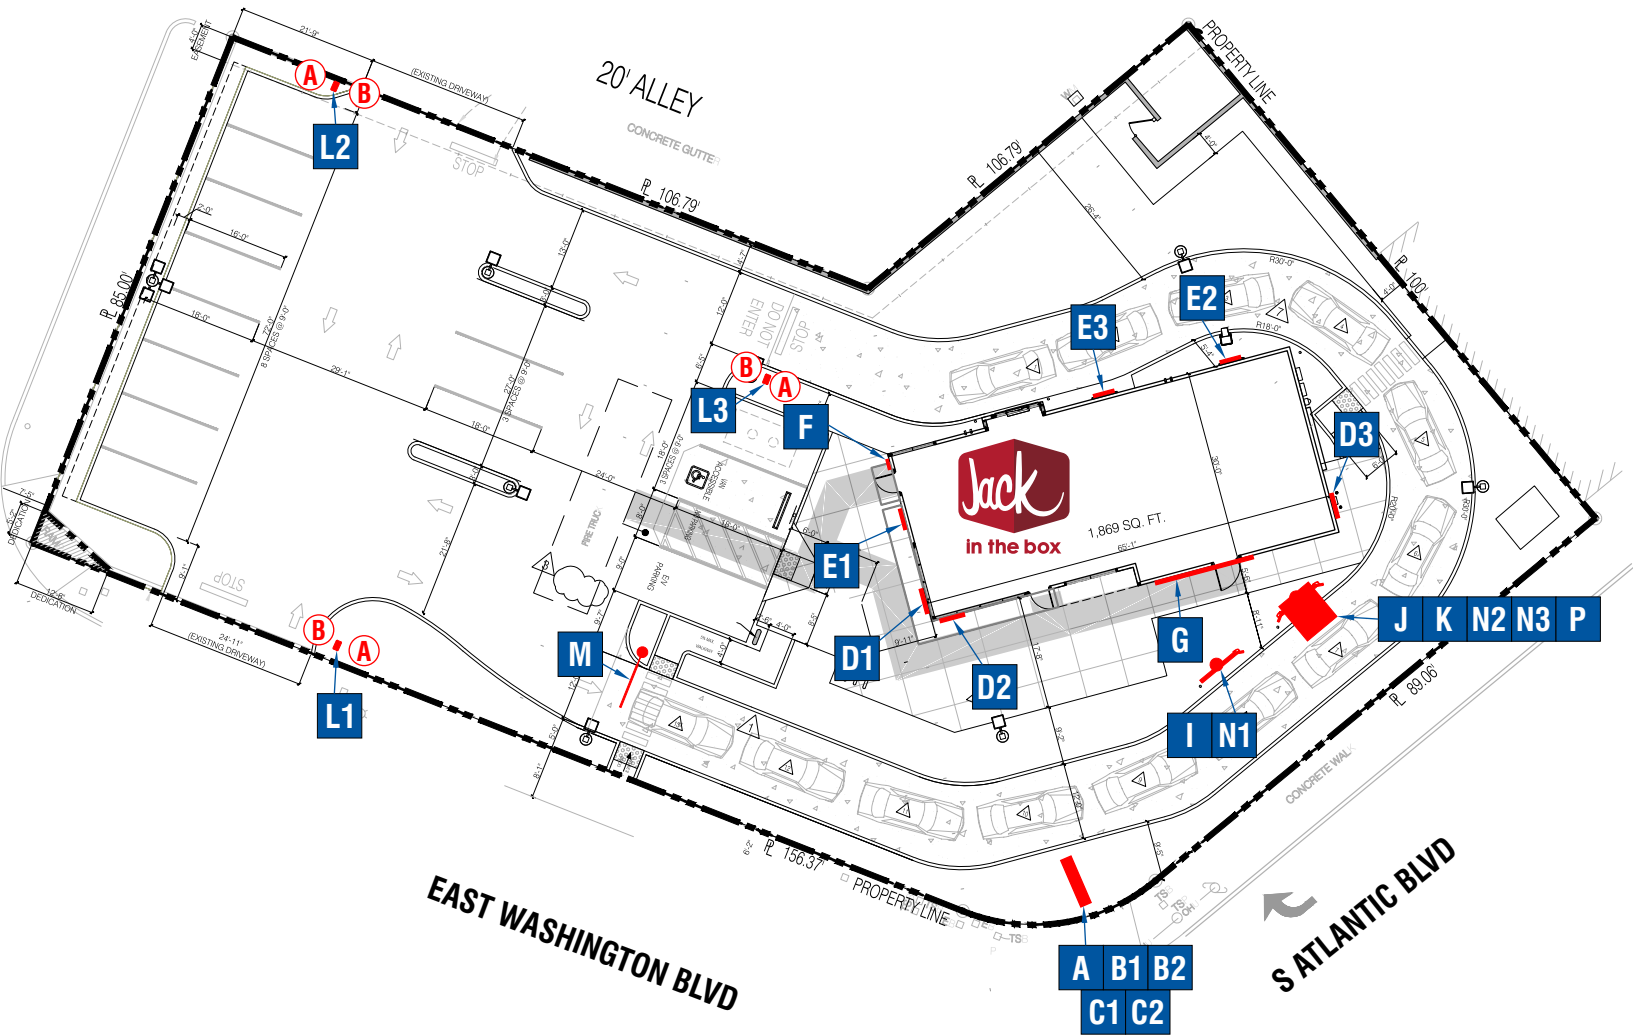

SITE PLAN

SCALE: 1"=30'-0"



4444 Federal Blvd San Diego, CA 92102
(619) 527-6100 signtech.com

JACK IN THE BOX

J5499
5133 E Washington Blvd, Commerce, CA 90040 USA

This design is the exclusive property of Signtech and cannot be reproduced in whole or in part, without their prior written approval

Sales: Bob McCarter
Project Manager: Steve Wood
Design: JMc
Engineering:

date: 7/1/25
drawing: J5499 Permit Package
revision: R1-7/8/25-JMc
project ID: JIB_5499_1



WEST / FRONT ELEVATION

SCALE: 1/8" = 1'-0"



SOUTH / RIGHT ELEVATION

SCALE: 1/8" = 1'-0"



4444 Federal Blvd San Diego, CA 92102
(619) 527-6100 signtech.com

JACK IN THE BOX

J5499
5133 E Washington Blvd, Commerce, CA 90040 USA

This design is the exclusive property of Signtech and cannot be reproduced in whole or in part, without their prior written approval


Sales: Bob McCarter
Project Manager: Steve Wood
Design: JMc
Engineering:

date: 7/1/25
drawing: J5499 Permit Package
revision: R1-7/8/25-JMc
project ID: JIB_5499_1



EAST / REAR ELEVATION

SCALE: 1/8" = 1'-0"

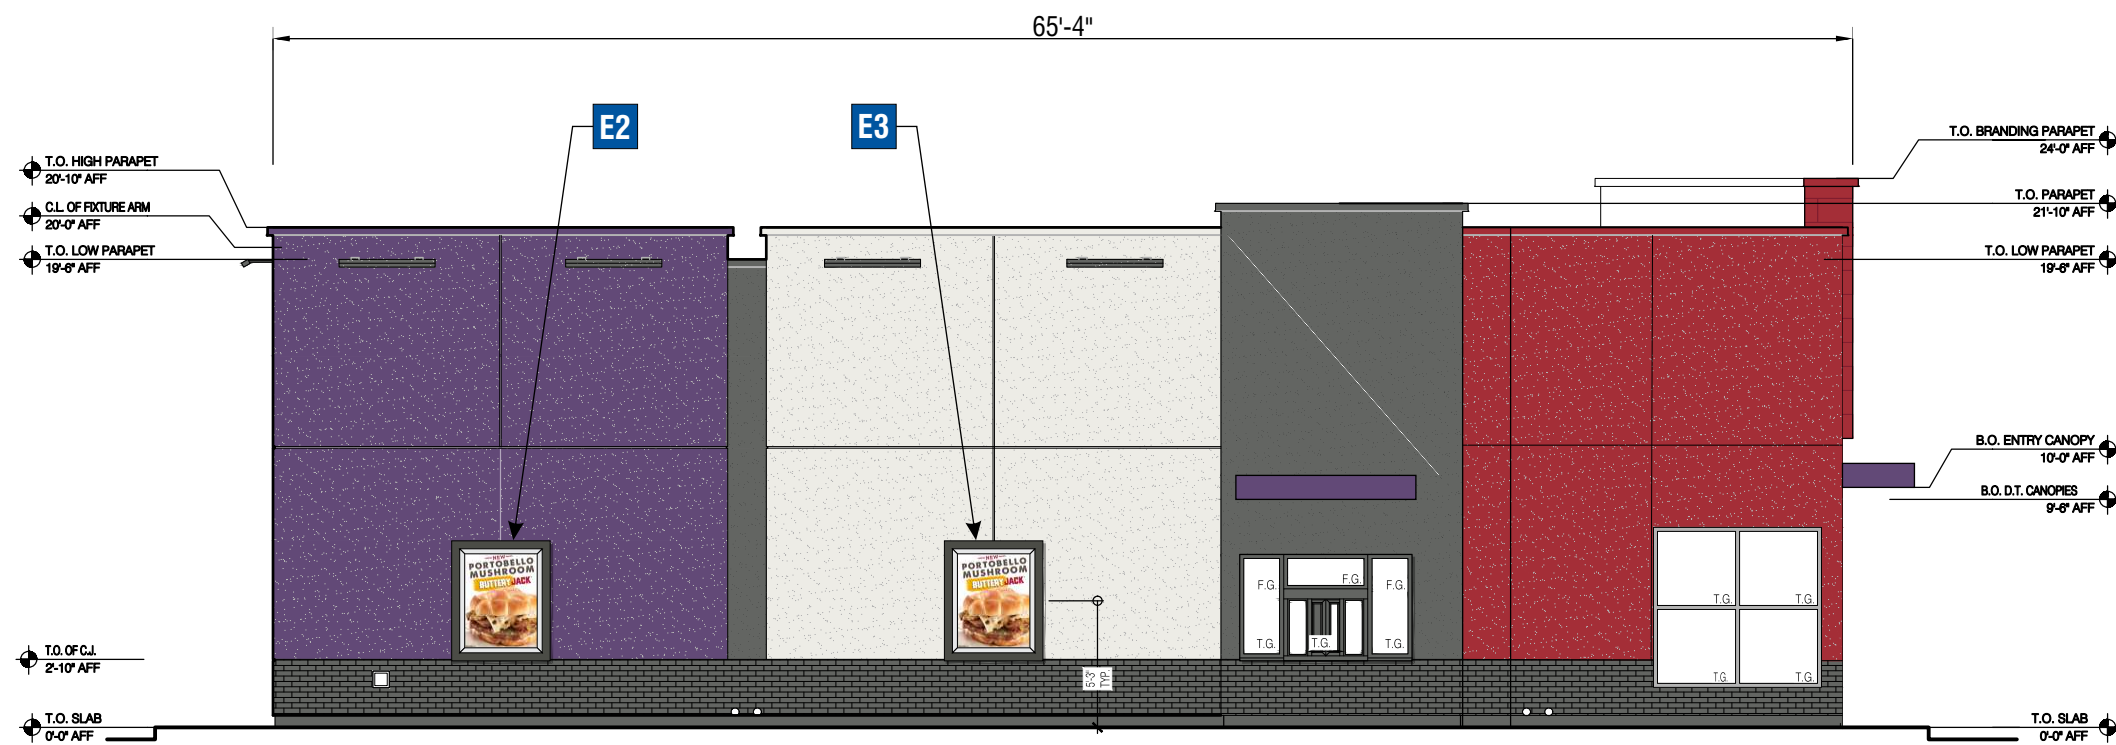

NORTH / LEFT ELEVATION

SCALE: 1/8" = 1'-0"



4444 Federal Blvd San Diego, CA 92102
(619) 527-6100 signtech.com




JACK IN THE BOX

J5499
5133 E Washington Blvd, Commerce, CA 90040 USA

This design is the exclusive property of Signtech and cannot be reproduced in whole or in part, without their prior written approval

Sales: Bob McCarter
Project Manager: Steve Wood
Design: JMc
Engineering:

date: 7/1/25
drawing: J5499 Permit Package
revision: R1-7/8/25-JMc
project ID: JIB_5499_1

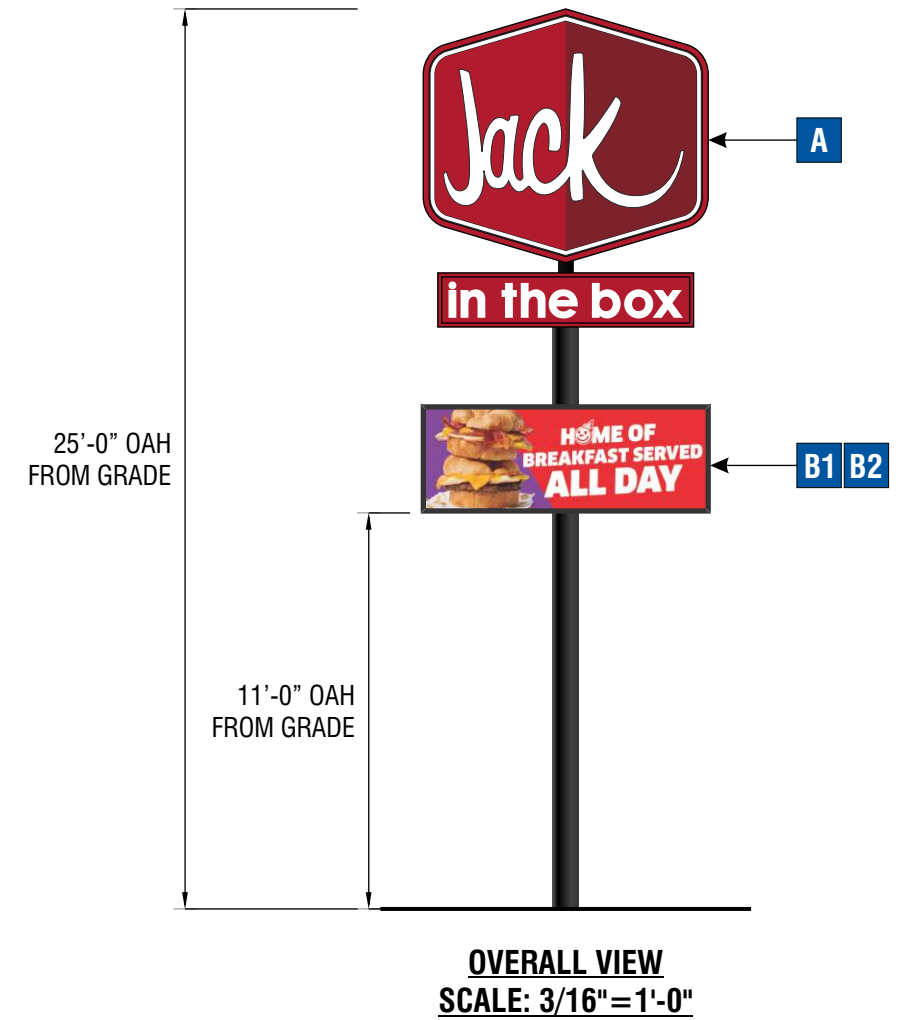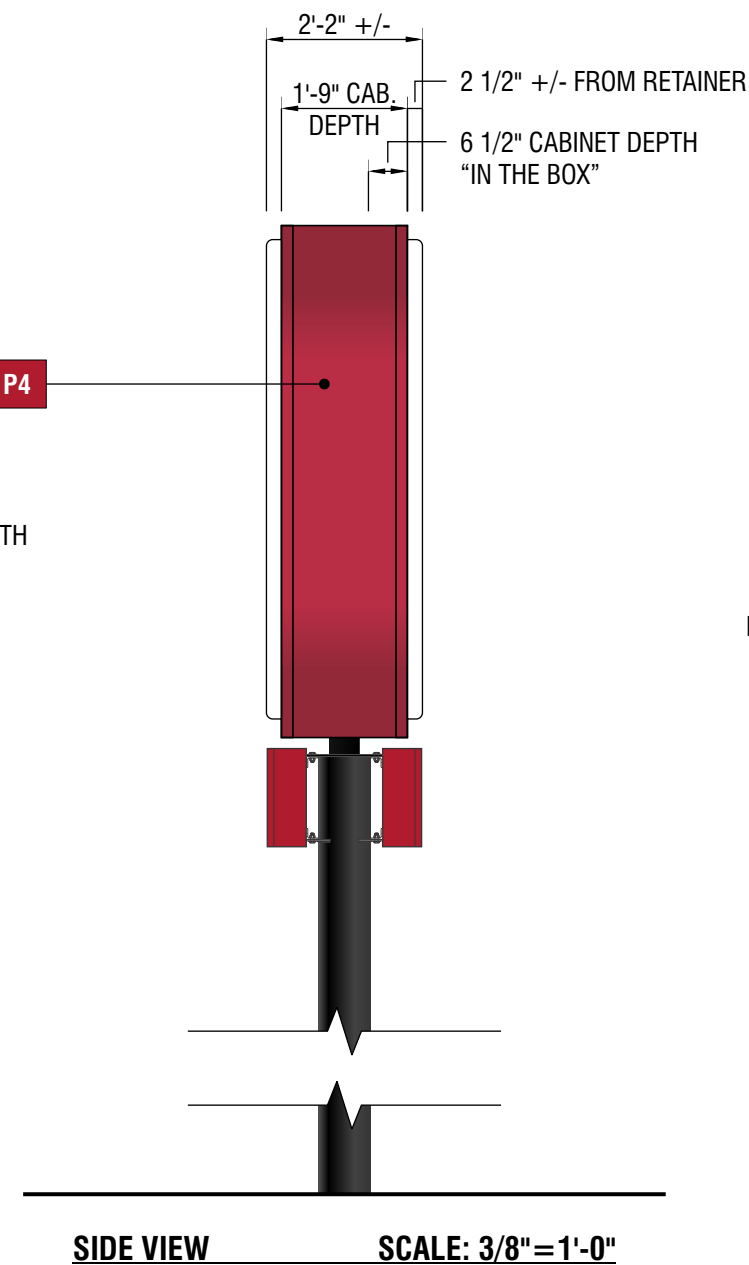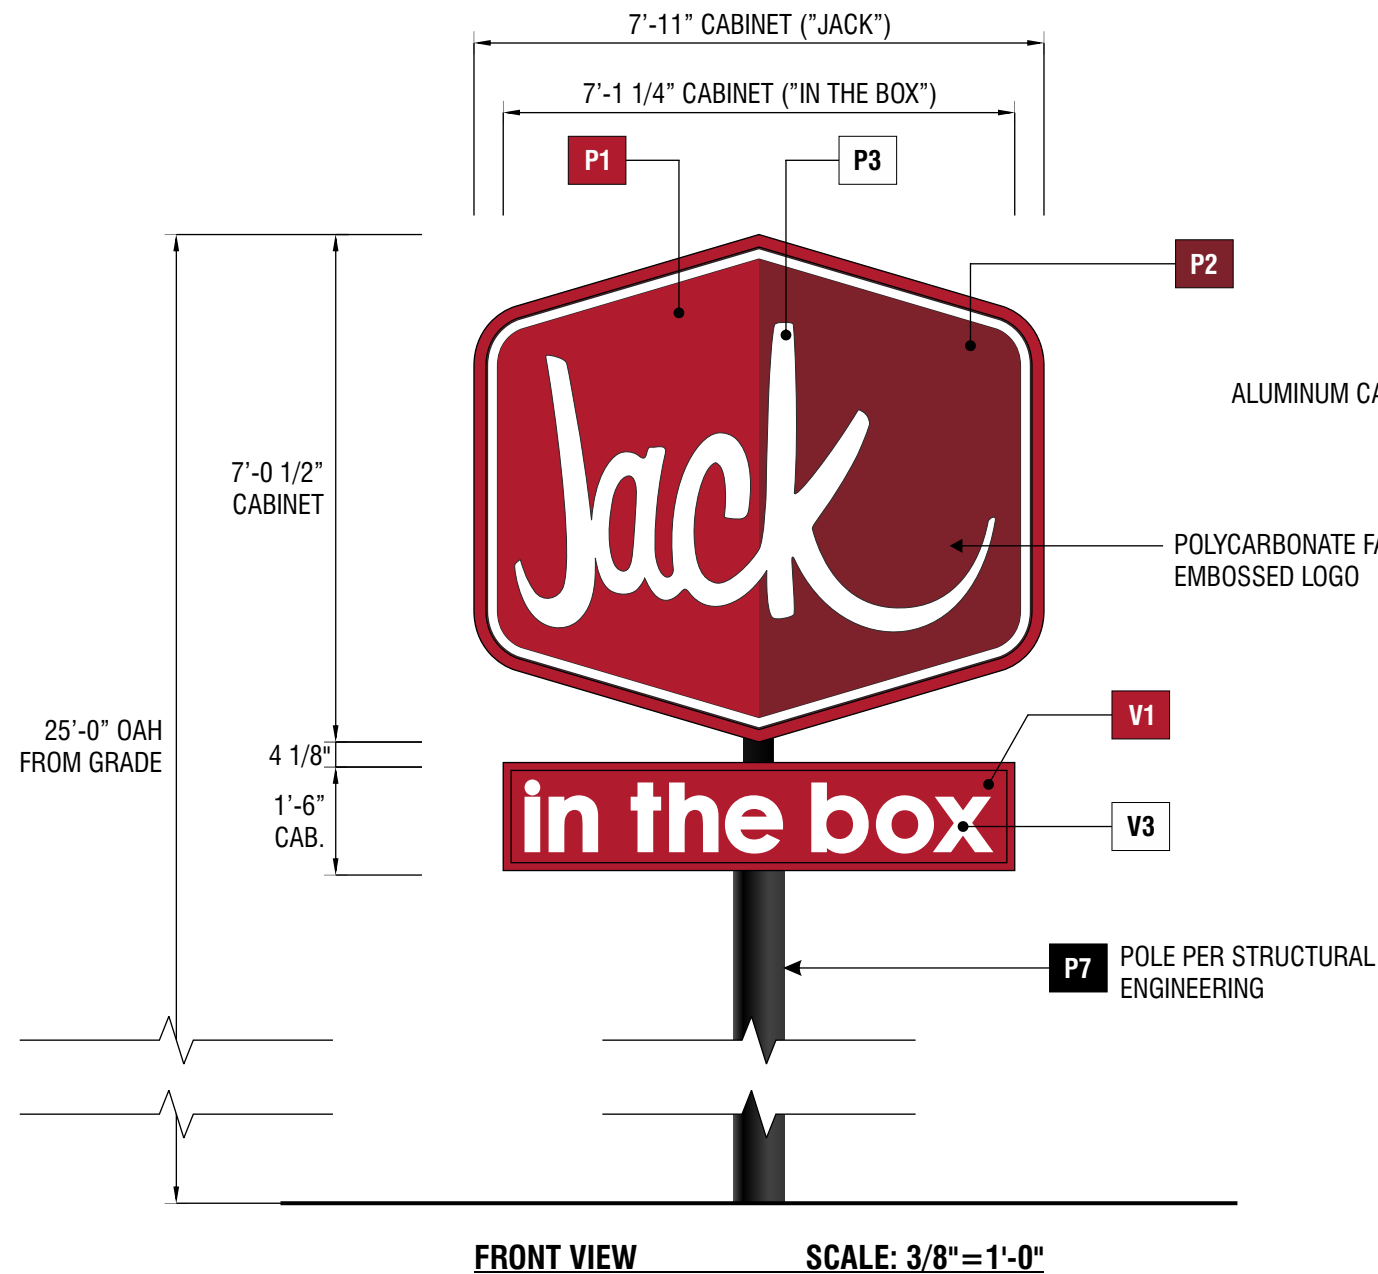

A SIGNTYPE JITB2-PYL-J67-106x95-300

MANUFACTURE AND INSTALL ONE (1) D/F INTERNALLY ILLUMINATED J67 PYLON SIGN

UPPER CABINET: FABRICATED ALUMINUM WITH INTERNAL LED ILLUMINATION

LOWER CABINET: FABRICATED ALUMINUM WITH INTERNAL LED ILLUMINATION

UPPER FACES: FORMED .150" CLEAR POLYCARBONATE WITH SECOND SURFACE PAINTED GRAPHICS

LOWER FACES: FLAT .177" CLEAR POLYCARBONATE WITH SECOND SURFACE VINYL GRAPHICS

POLE: STEEL POLE PER STRUCTURAL ENGINEERING

ILLUMINATION: LED - PRINCIPAL QM3 7100K WHITE

PAINT

P1 LACRYL SERIES 400
LW-5-9404-1 *TRANSLUCENT PAINT*

P2 LACRYL SERIES 400
443 'DEEP RED' *TRANSLUCENT PAINT*

P3 LACRYL SERIES 400
L-403-W *TRANSLUCENT PAINT*

P4 TO MATCH MP 64691 'JIB RED'
OPAQUE PAINT

P7 PAINT TO MATCH RAL 9004
'SIGNAL BLACK' W/ SATIN FINISH

VINYL

V1 3M 3630-73 'DARK RED'

V3 3M 3630-20 'WHITE'



4444 Federal Blvd San Diego, CA 92102
(619) 527-6100 signtech.com


JACK IN THE BOX

J5499
5133 E Washington Blvd, Commerce, CA 90040 USA

This design is the exclusive property of Signtech and cannot be reproduced in whole or in part, without their prior written approval


Sales: Bob McCarter
Project Manager: Steve Wood
Design: JMc
Engineering:

date: 7/1/25
drawing: J5499 Permit Package
revision: R1-7/8/25-JMc
project ID: JIB_5499_1

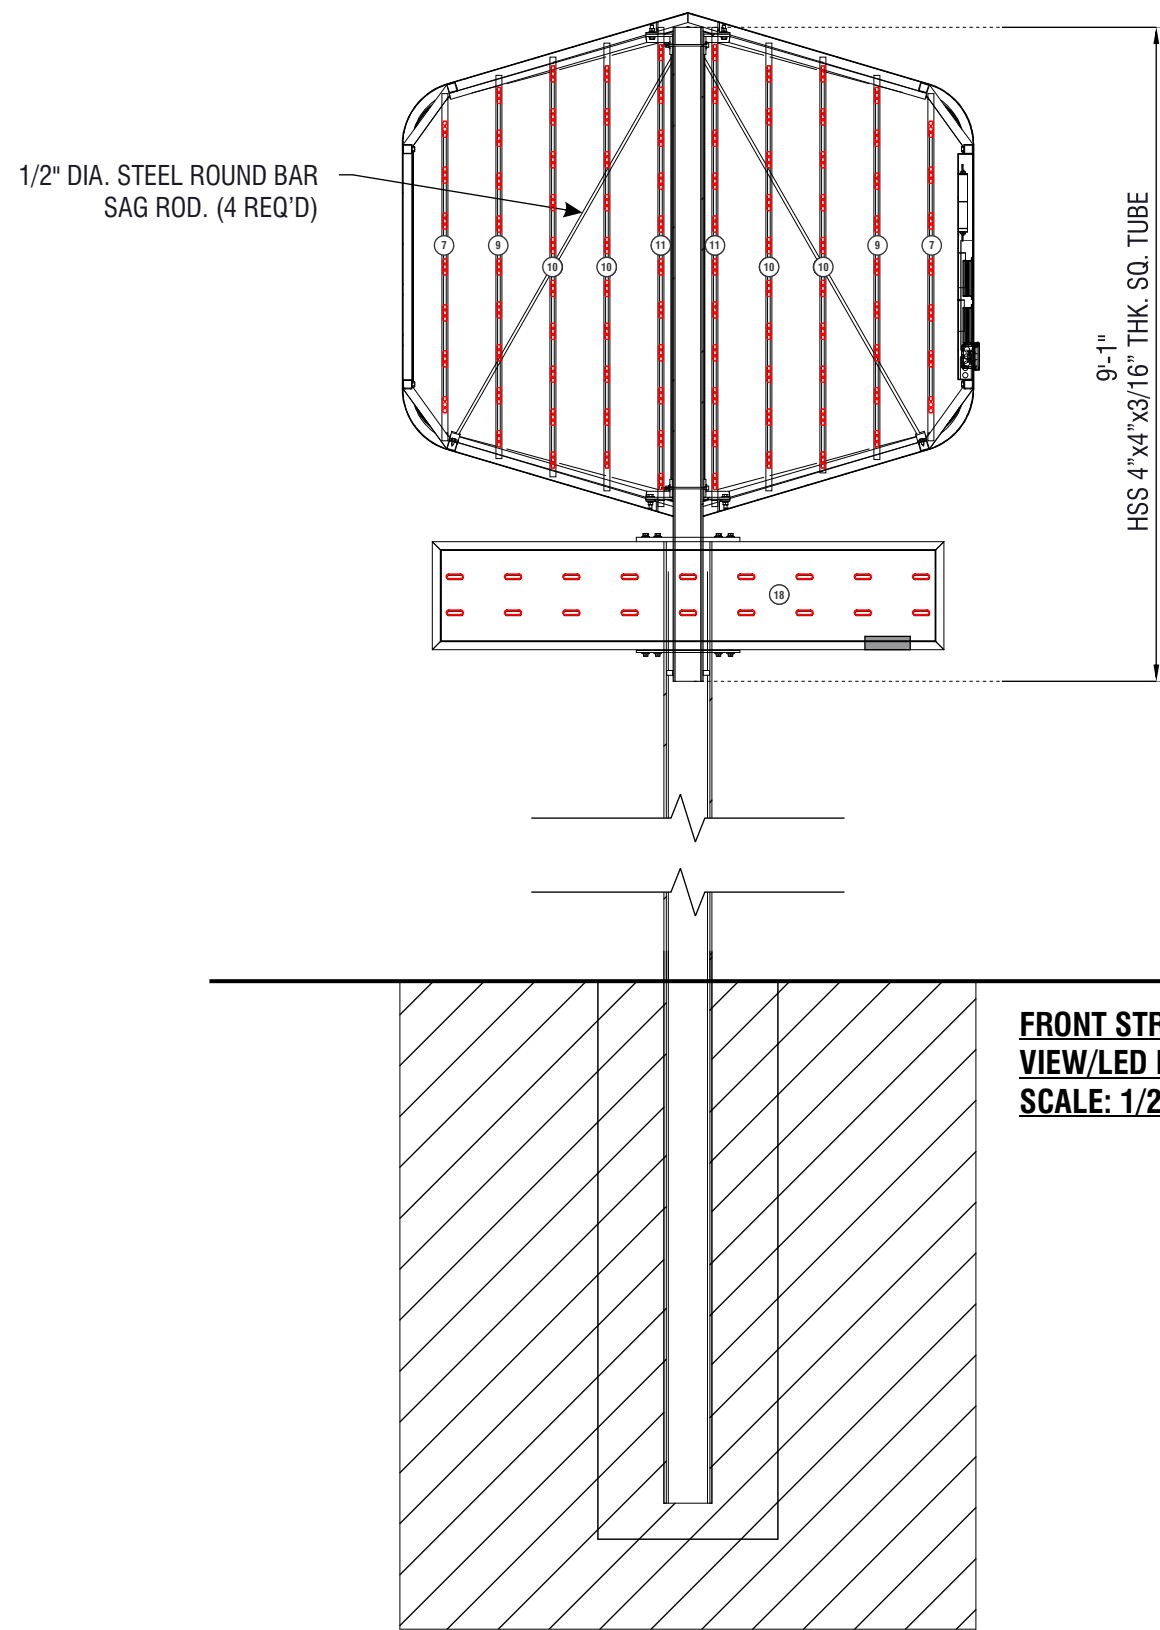

**FRONT STRUCTURAL
VIEW/LED LAYOUT**
SCALE: 1/2"=1'-0"

- (224) PL-QM3-SW200-P PRINCIPAL QWIK MOD3 WHITE 7100K
- (2) MEAN WELL HLG-150H-12A POWER SUPPLIES @ 1.7 AMPS E320521
- (1) MEAN WELL LPV-60-12 POWER SUPPLY @ 1.2 AMPS
- TOTAL ELECTRICAL LOAD = 4.6 AMPS
- (2) TRANSCO (E129809) TOGGLE SWITCH S/P W-BOOT W/P DISCONNECT SWITCHES REQUIRED
- (1) DEDICATED 20 AMPS. x 120 VOLT x 60 Hz CIRCUIT TO BE PROVIDED BY CUSTOMER
- UL & DATA LABELS ARE REQUIRED

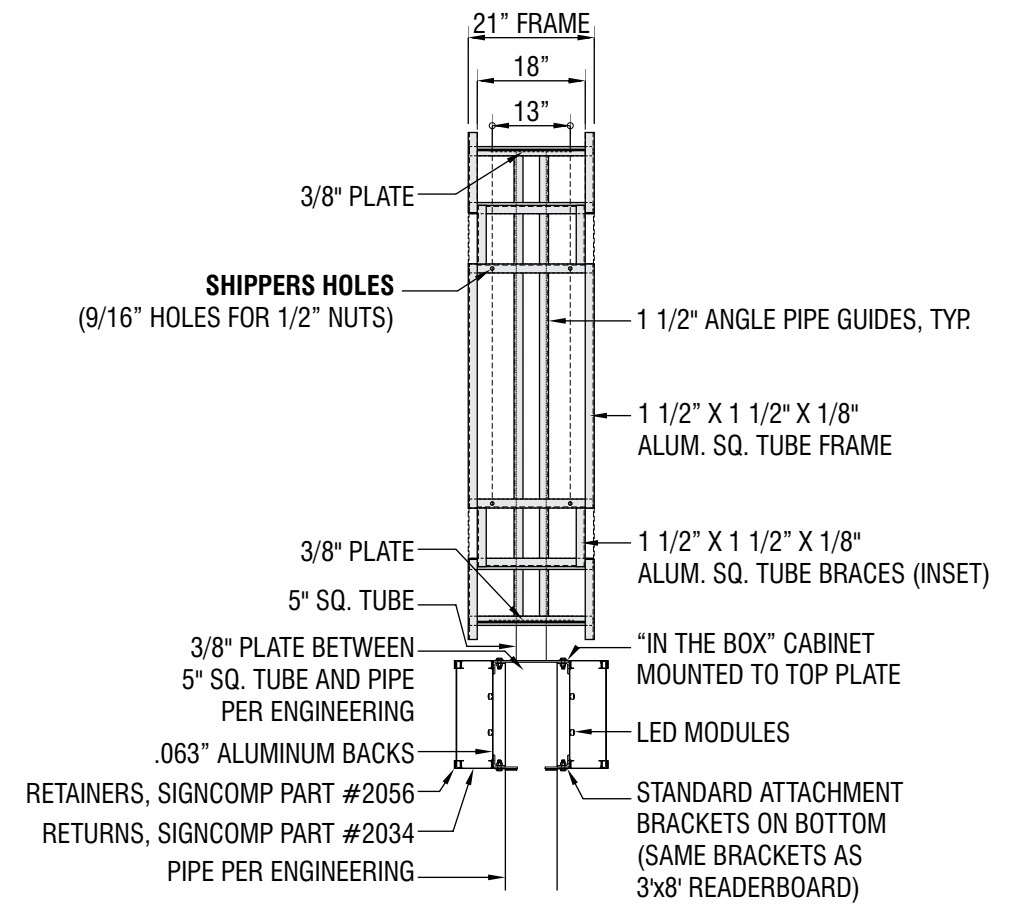

SECTION VIEW **SCALE: 3/8"=1'-0"**



B1 B2 SIGNTYPE JITB-RB-36x96

MANUFACTUER AND INSTALL TWO (2) D/F INTERNALLY ILLUMINATED S/F READERBOARD CABINETS

CABINET BODY: SIGNCOMP ALUM. EXTRUSION PART NO. 2034, WITH INTERNAL LED ILLUMINATION

CABINET RETAINERS: SIGNCOMP ALUM. EXTRUSION PART NO. 2056, PAINTED TO MATCH "P1"

FACES: .150" THICK CLEAR POLYCARBONATE WITH SECOND SURFACE DIGITAL PRINT

CABINET BACK: .063" ALUM. PRE-PAINTED WHITE, PAINT BACK SIDE TO MATCH "P9"

ILLUMINATION: LED - PRINCIPAL QWIK MOD 3 - 7100K WHITE

PAINT

P7 MATTHEWS SV923 BLACK
W/ SATIN FINISH

MATERIALS

M4 .150" CLEAR POLYCARBONATE WITH
SECOND SURFACE DIRECT DIGITAL PRINT
SEE FACE DETAIL PAGE



4444 Federal Blvd San Diego, CA 92102
(619) 527-6100 signtech.com


JACK IN THE BOX

J5499
5133 E Washington Blvd, Commerce, CA 90040 USA



This design is the exclusive property of Signtech and cannot be reproduced in whole or in part, without their prior written approval

Sales: Bob McCarter
Project Manager: Steve Wood
Design: JMc
Engineering:

date: 7/1/25
drawing: J5499 Permit Package
revision: R1-7/8/25-JMc
project ID: JIB_5499_1

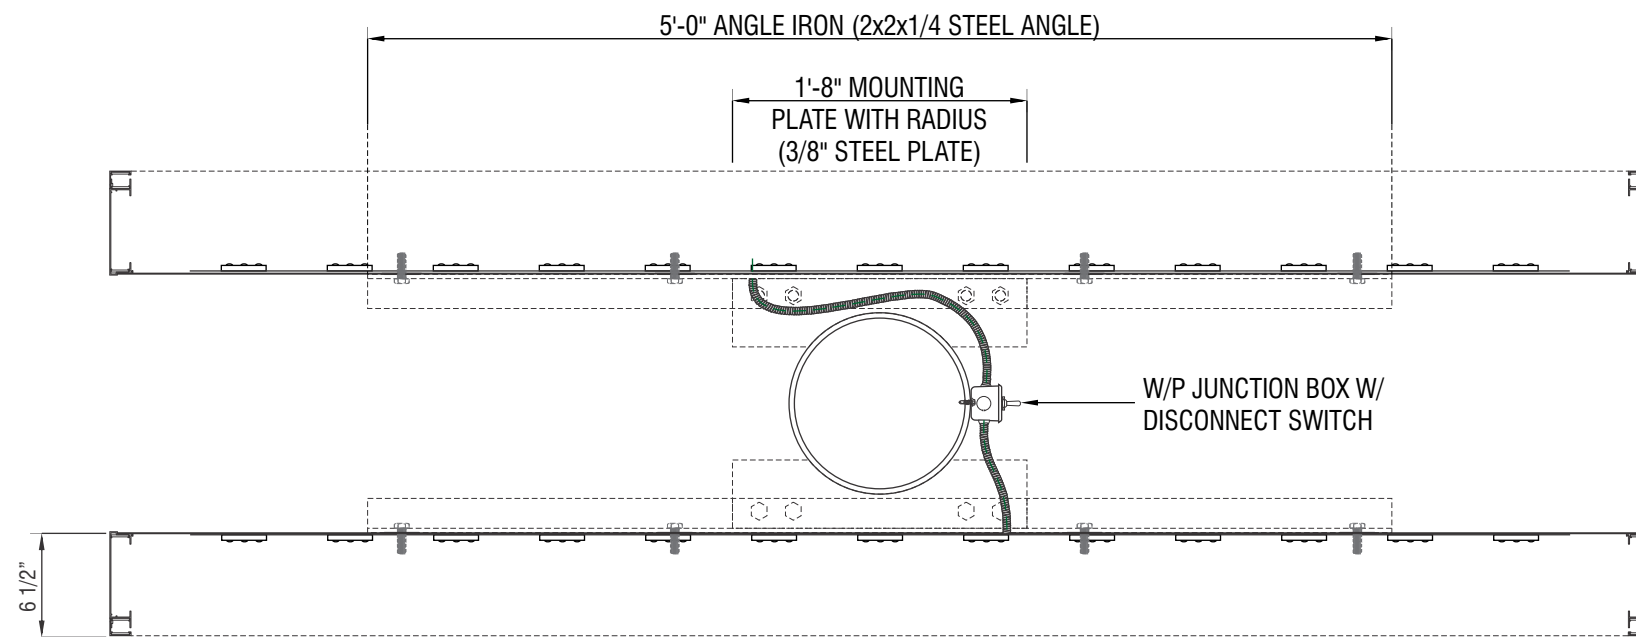


TOP VIEW SECTION SCALE: 1" = 1'-0"

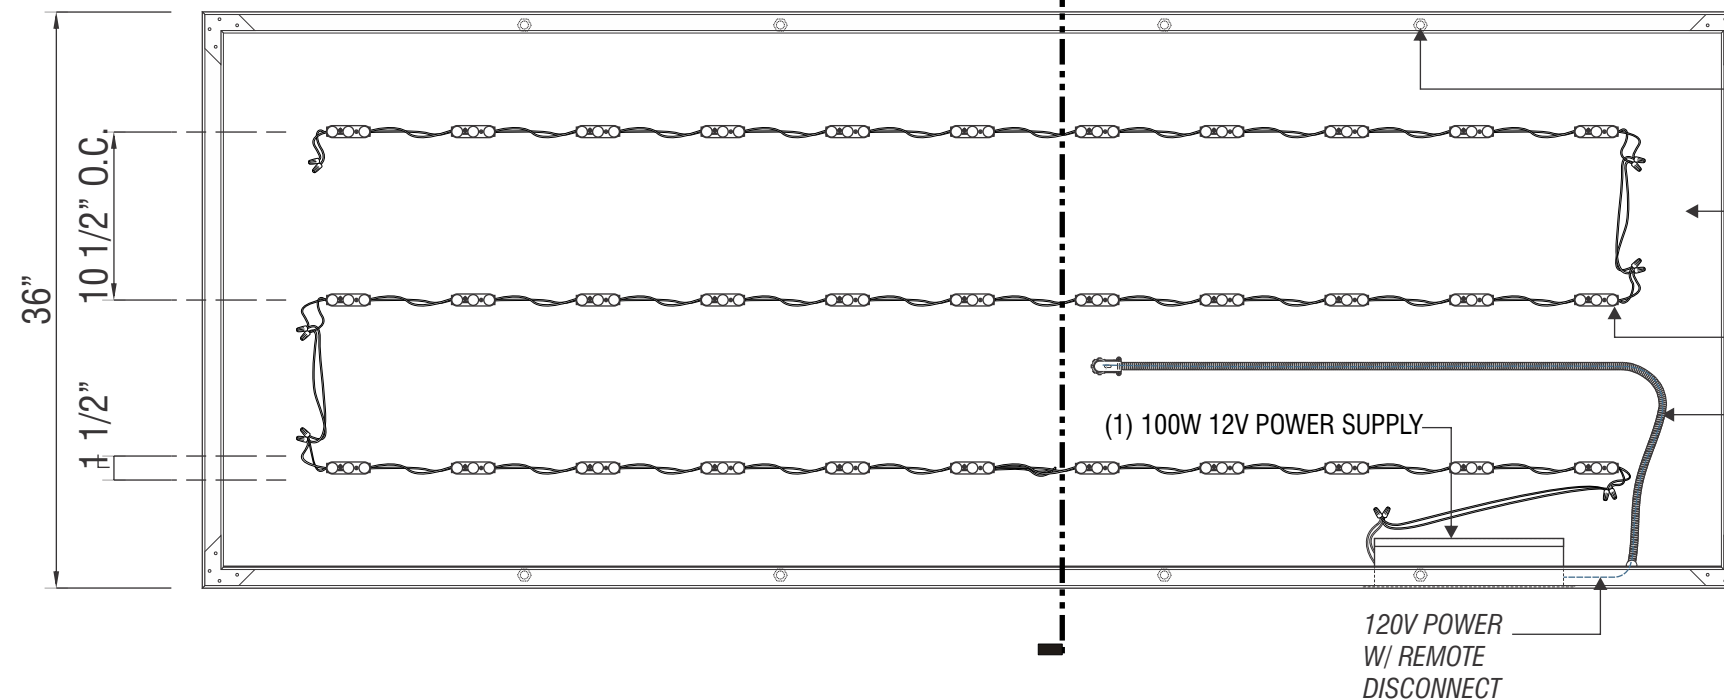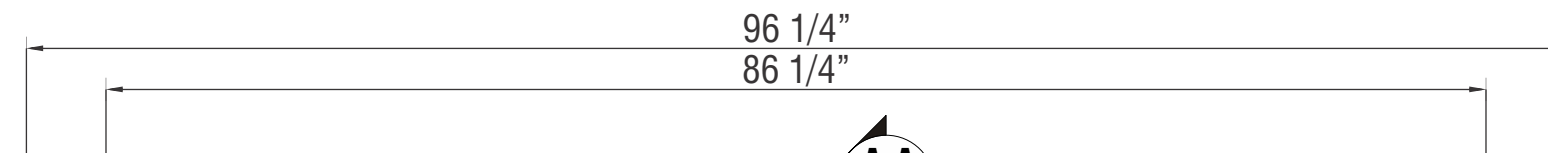

FRONT VIEW - CABINET ASSEMBLY, NO FACE

SCALE: 1" = 1'-0"

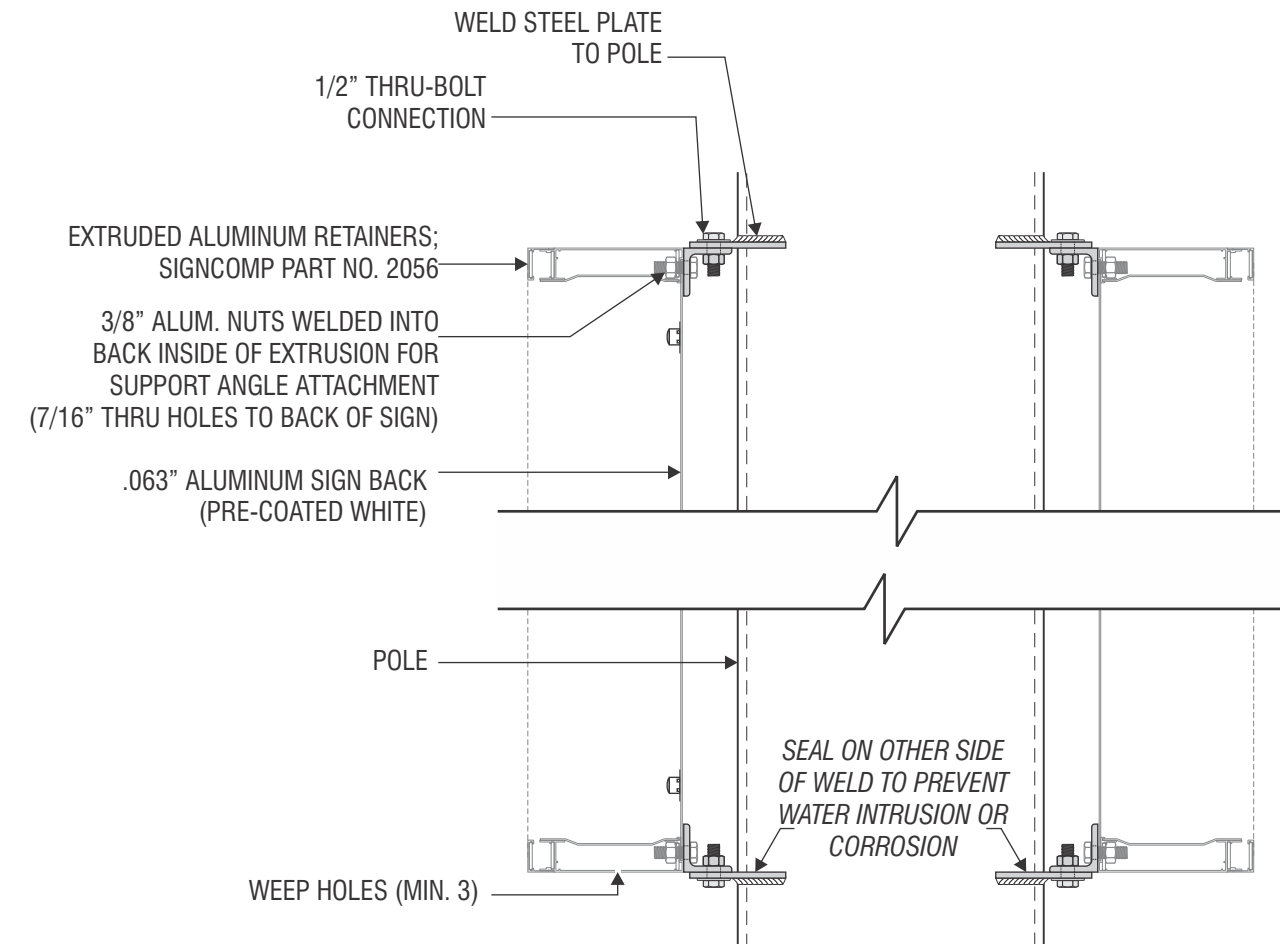

A-A SECTION DETAIL SCALE: 3/4" = 1'-0"

- 3/8" ALUM. NUTS WELDED INTO BACK INSIDE OF EXTRUSION FOR SUPPORT ANGLE ATTACHMENT (7/16" THRU HOLES TO BACK OF SIGN)
- .063" ALUMINUM SIGN BACK (PRE-COATED WHITE)
- (33) PRINCIPAL QWIK MOD 3 7100K WHITE LEDS ATTACHED WITH VHB TAPE TO ALUMINUM BACK
- FLEXIBLE CONDUIT (PRIMARY ELECTRICAL)
- EXTRUDED ALUMINUM SIGN CABINET; SIGNCOMP PART NO. 2034
- (12) STD. CORNER KEY SIGNCOMP PART NO. 5210



4444 Federal Blvd San Diego, CA 92102
(619) 527-6100 signtech.com

JACK IN THE BOX

J5499
5133 E Washington Blvd, Commerce, CA 90040 USA

This design is the exclusive property of Signtech and cannot be reproduced in whole or in part, without their prior written approval

Sales: Bob McCarter
Project Manager: Steve Wood
Design: JMc
Engineering:

date: 7/1/25
drawing: J5499 Permit Package
revision: R1-7/8/25-JMc
project ID: JIB_5499_1



FRONT VIEW (BREAKFAST)

SCALE: 3/4"=1'-0"

C1 SIGNTYPE **JITB-RF-RB-35x95-BREAKFAST ALL DAY**

MANUFACTURE AND INSTALL ONE (1) READERBOARD FACE - BREAKFAST ALL DAY
FACE: .150" CLEAR POLYCARBONATE W/ SECOND SURFACE DIGITAL PRINT GRAPHICS




FRONT VIEW (TACOS)

SCALE: 3/4"=1'-0"

C2 SIGNTYPE **JITB-RF-RB-35x95-TACOS**

MANUFACTURE AND INSTALL ONE (1) READERBOARD FACE - TACOS
FACE: .150" CLEAR POLYCARBONATE W/ SECOND SURFACE DIGITAL PRINT GRAPHICS

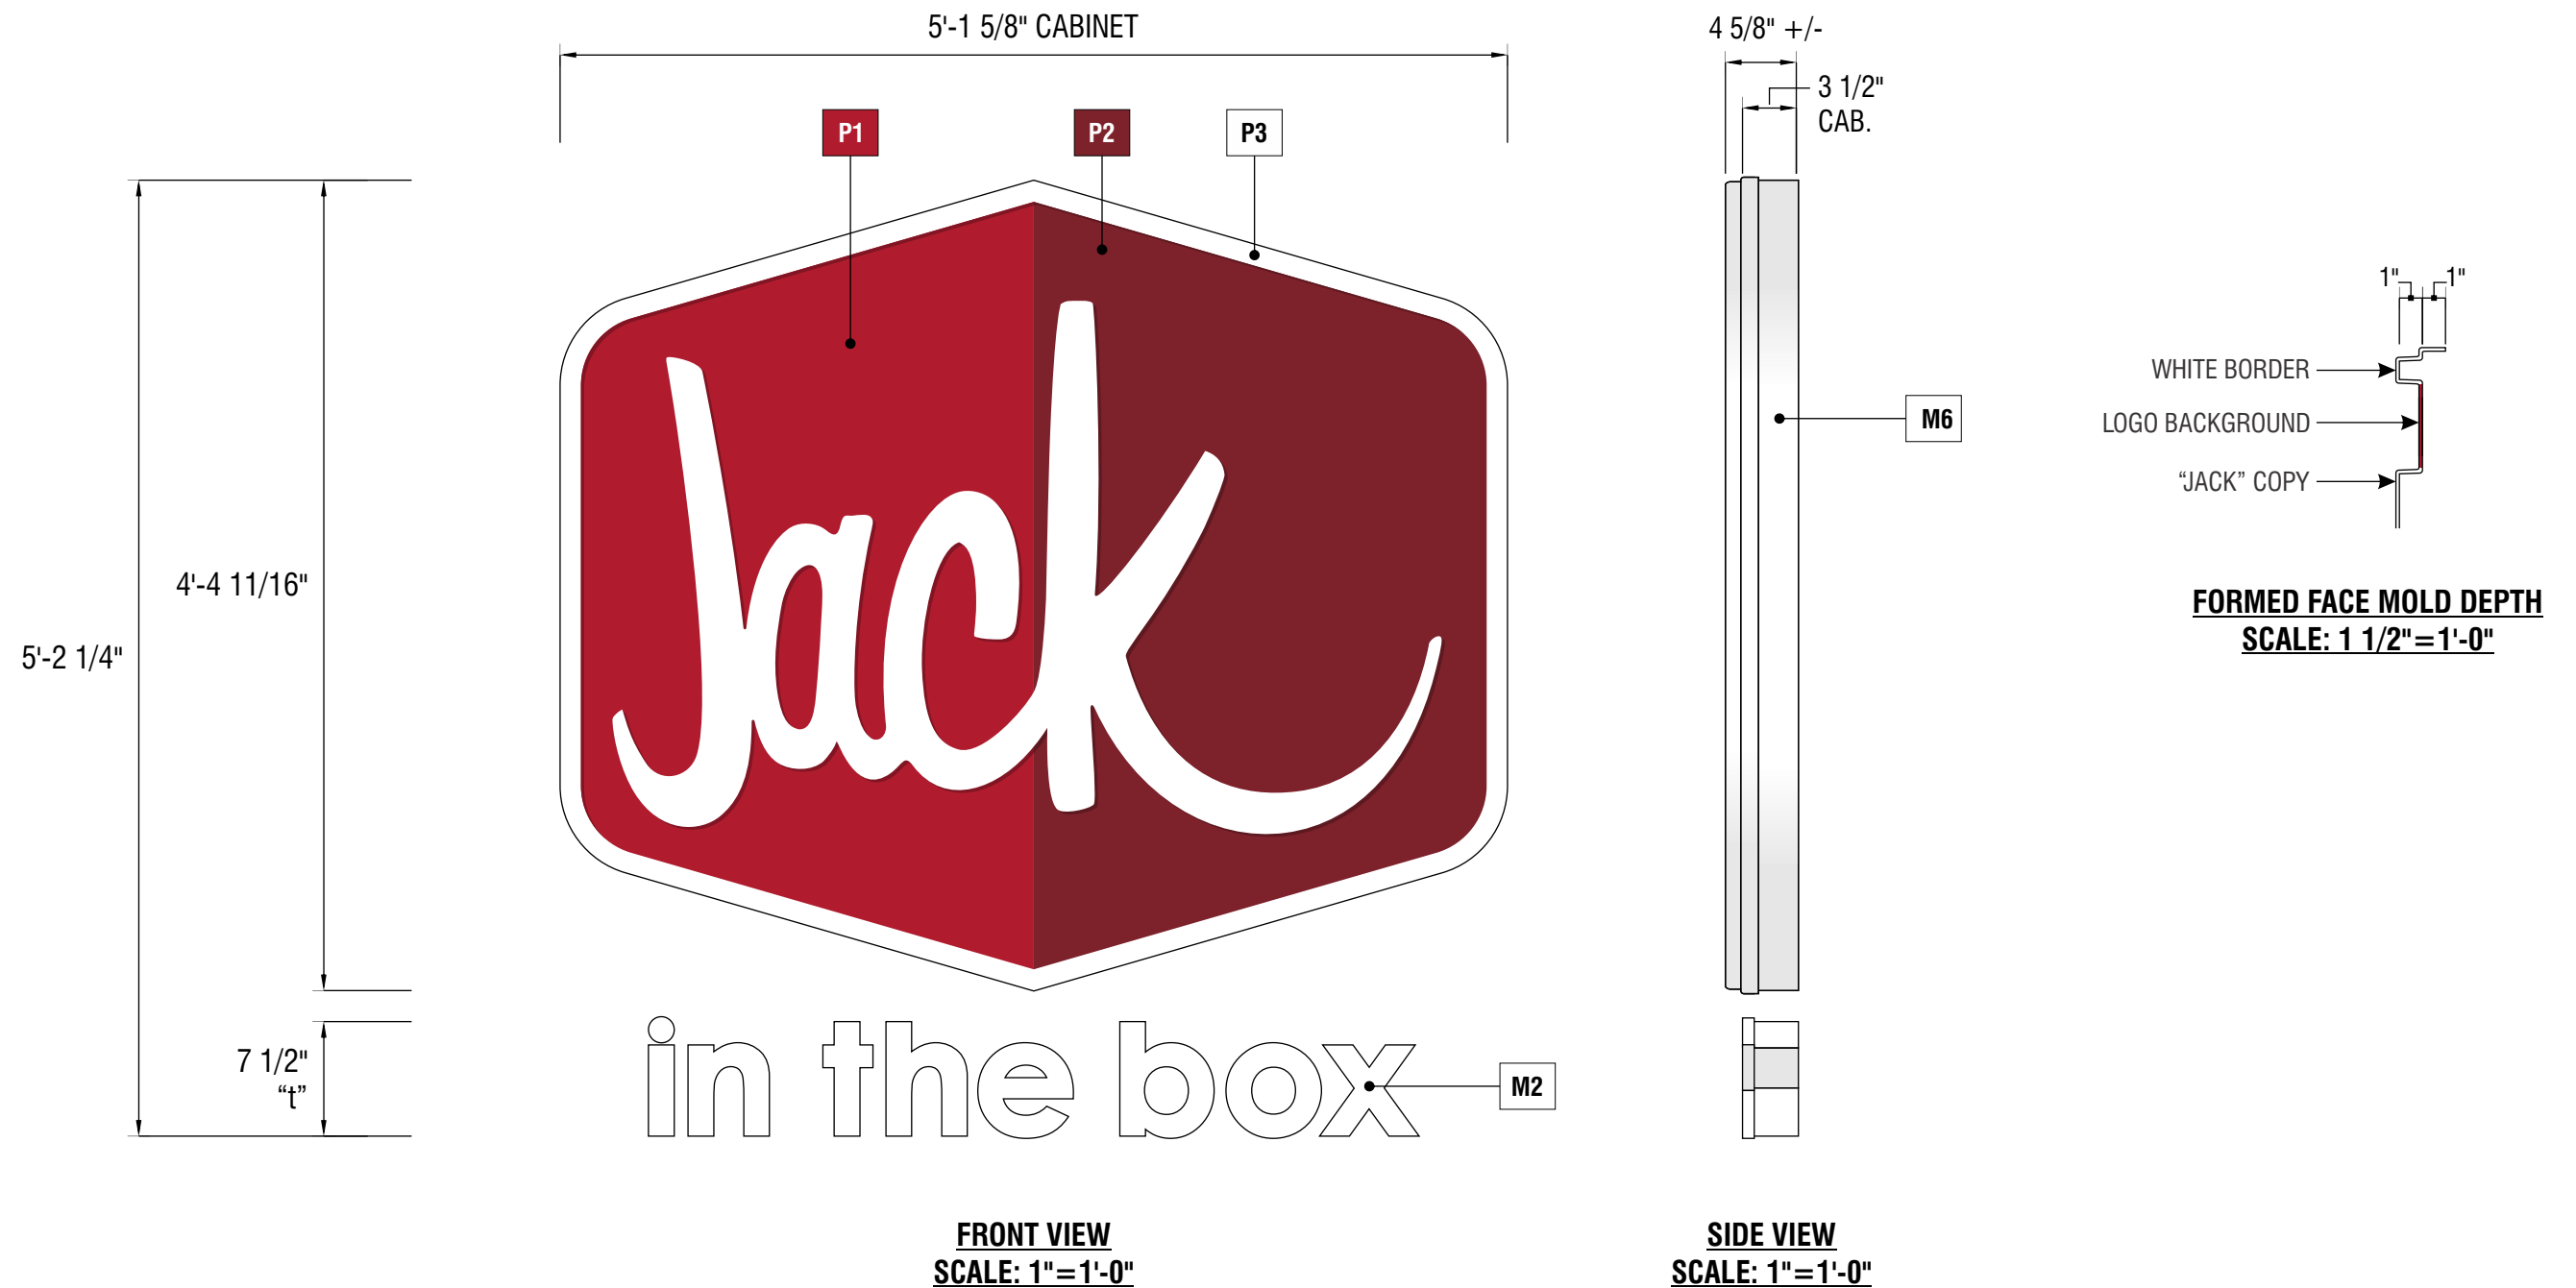

D1 D2 SIGNTYPE JITB2-J30

MANUFACTURE AND INSTALL TWO (2) INTERNALLY ILLUMINATED J30 WALL SIGNS

UPPER CABINET: ALUMINUM WITH INTERNAL LED ILLUMINATION AND UL APPROVED

DISCONNECT SWITCH - .040" THICK 3 1/2" CHANNEL LETTER COIL PRE-COATED WHITE WITH SATIN FINISH

UPPER FACE: FORMED .118" CLEAR POLYCARBONATE WITH SECOND SURFACE PAINTED GRAPHICS

CHANNEL LETTERS: .040" THICK 3 1/2" CHANNEL LETTER COIL - PRECOATED WHITE WITH SATIN FINISH

CHANNEL LETTER FACES: 3/16" WHITE ACRYLIC WITH 3/4" WHITE JEWELITE TRIMCAP

BACKS: .050" PRE-COATED WHITE ALUMINUM

ILLUMINATION: 7100K PRINCIPAL QWIK MOD 3 (UPPER CABINET), 7100K PRINCIPAL QWIK MOD 1 (LETTERS)

PAINT

- P1** LACRYL SERIES 400
 LW-5-9404-1 *TRANSLUCENT PAINT*
- P2** LACRYL SERIES 400
 443 'DEEP RED' *TRANSLUCENT PAINT*

MATERIALS

- M6** 3 1/2" CHANNEL LETTER COIL PRE-COATED
 WHITE WITH SATIN FINISH
- M2** 3/16" WHITE ACRYLIC



4444 Federal Blvd San Diego, CA 92102
 (619) 527-6100 signtech.com



JACK IN THE BOX

J5499
 5133 E Washington Blvd, Commerce, CA 90040 USA

This design is the exclusive property of Signtech and cannot be reproduced in whole or in part, without their prior written approval

Sales: Bob McCarter
Project Manager: Steve Wood
Design: JMc
Engineering:

date: 7/1/25
drawing: J5499 Permit Package
revision: R1-7/8/25-JMc
project ID: JIB_5499_1

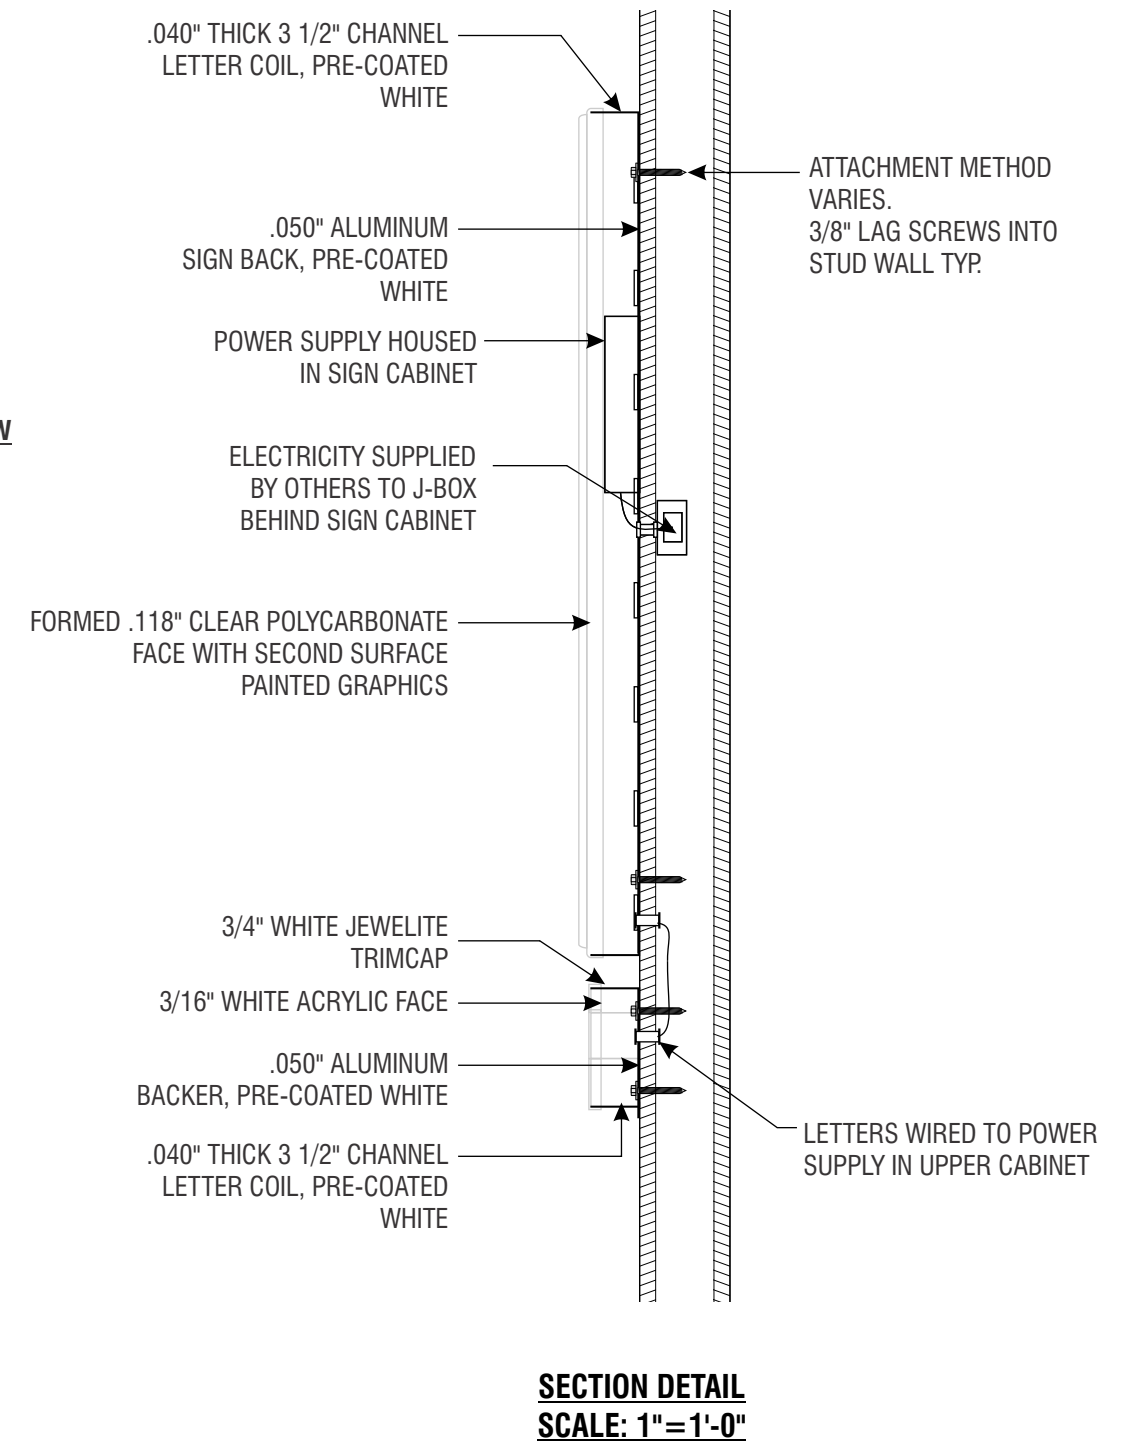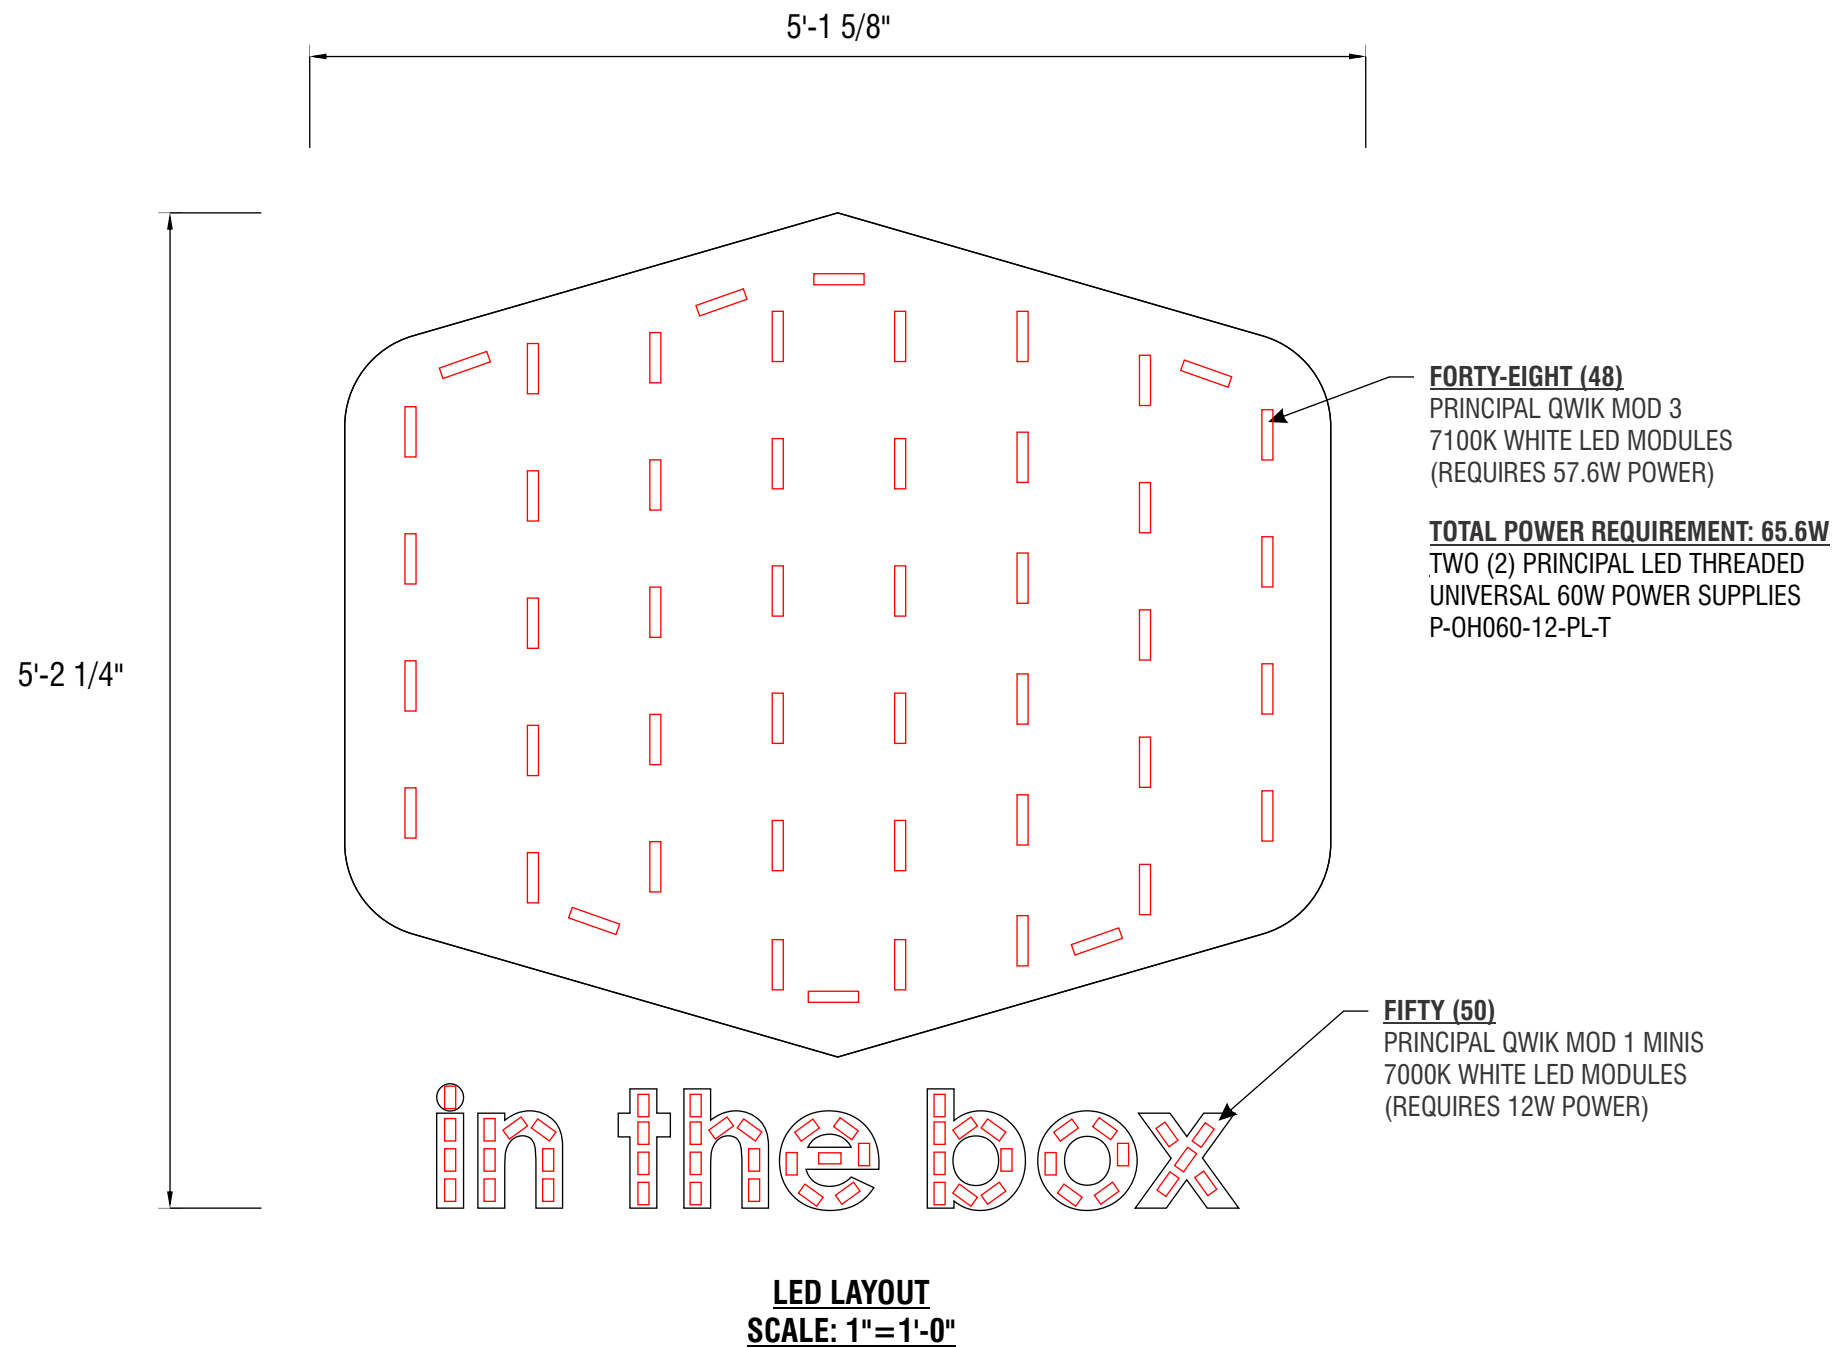



FRONT VIEW
SCALE: 1"=1'-0"

SIDE VIEW
SCALE: 1"=1'-0"

D3 SIGNTYPE JITB2-J30-R

MANUFACTURE AND INSTALL ONE (1) INTERNALLY ILLUMINATED J30 WALL SIGN WITH RED LETTERS

UPPER CABINET: ALUMINUM WITH INTERNAL LED ILLUMINATION AND UL APPROVED

DISCONNECT SWITCH - .040" THICK 3 1/2" CHANNEL LETTER COIL PRE-COATED WHITE WITH SATIN FINISH

UPPER FACE: FORMED .118" CLEAR POLYCARBONATE WITH SECOND SURFACE PAINTED GRAPHICS

CHANNEL LETTERS: .040" THICK 3 1/2" CHANNEL LETTER COIL - PRECOATED RED WITH SATIN FINISH

CHANNEL LETTER FACES: 3/16" RED ACRYLIC WITH 3/4" RED JEWELITE TRIMCAP

BACKS: .050" PRE-COATED WHITE ALUMINUM

ILLUMINATION: 7100K PRINCIPAL QWIK MOD 3 (UPPER CABINET), 7100K PRINCIPAL QWIK MOD 1 (LETTERS)

PAINT

P1 LACRYL SERIES 400
LW-5-9404-1 *TRANSLUCENT PAINT*

P2 LACRYL SERIES 400
443 'DEEP RED' *TRANSLUCENT PAINT*

P3 LACRYL SERIES 400
L-403-W *TRANSLUCENT PAINT*

MATERIAL

M1 3/16" RED ACRYLIC

M5 3 1/2" CHANNEL LETTER COIL
PRE-COATED "JIB RED"

M6 3 1/2" CHANNEL COIL
PRE-COATED WHITE
WITH SATIN FINISH



4444 Federal Blvd San Diego, CA 92102
(619) 527-6100 signtech.com



JACK IN THE BOX



J5499
5133 E Washington Blvd, Commerce, CA 90040 USA

This design is the exclusive property of Signtech and cannot be reproduced in whole or in part, without their prior written approval

Sales: Bob McCarter
Project Manager: Steve Wood
Design: JMc
Engineering:

date: 7/1/25
drawing: J5499 Permit Package
revision: R1-7/8/25-JMc
project ID: JIB_5499_1

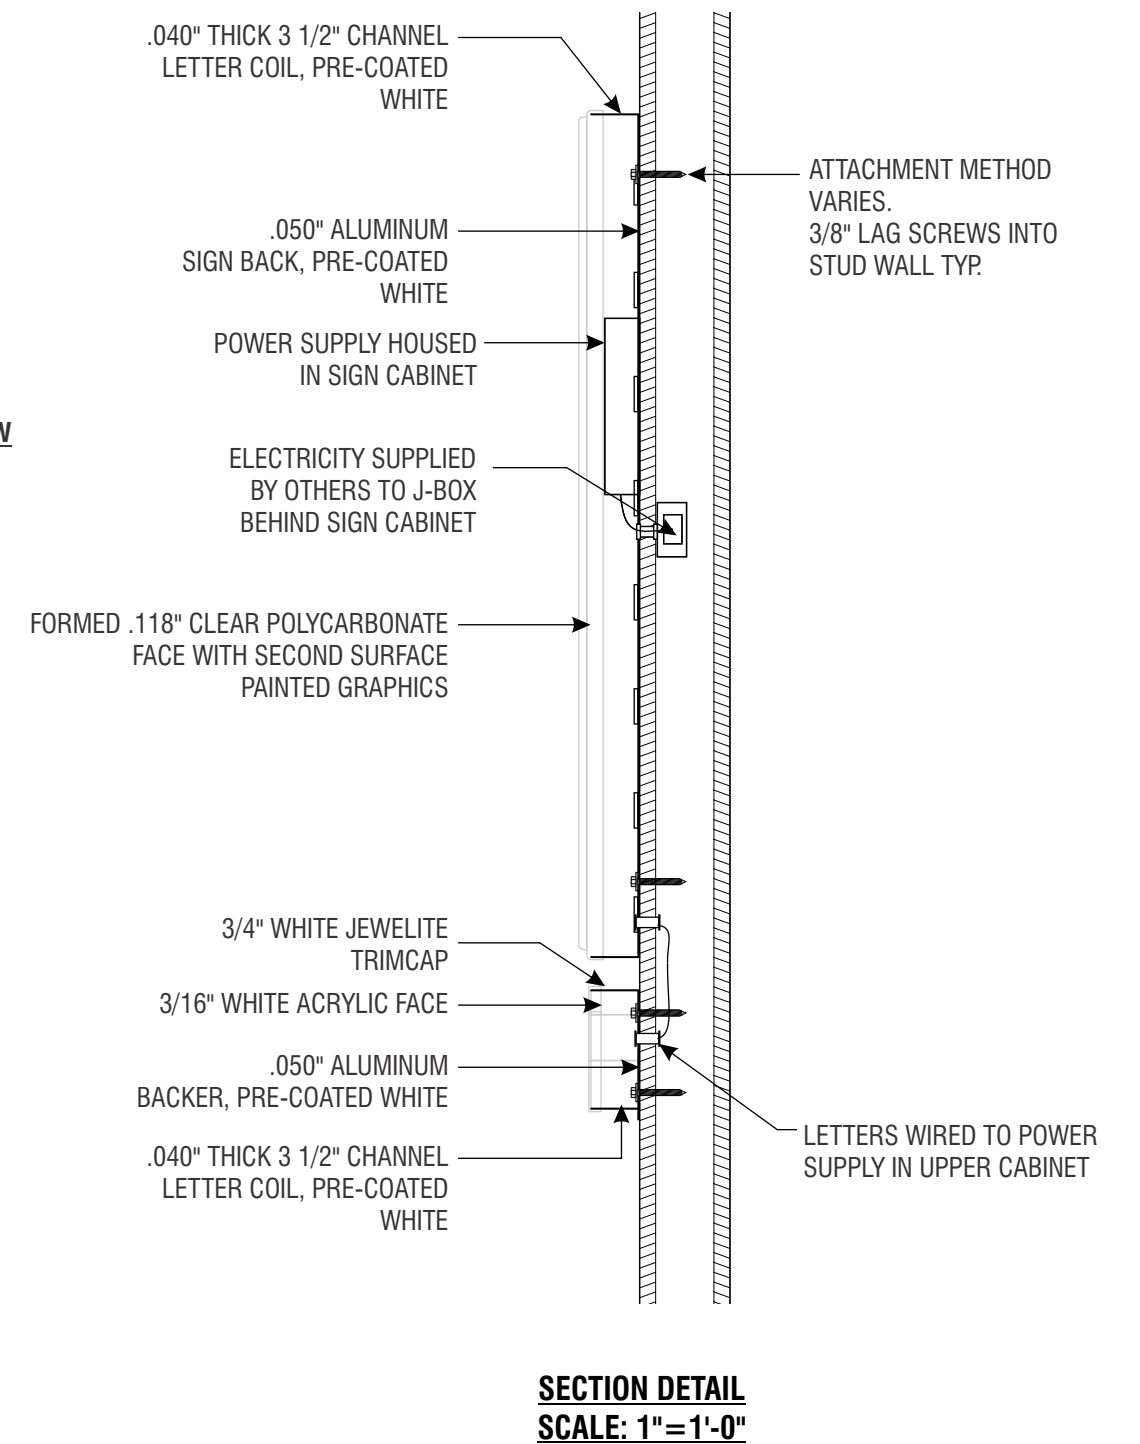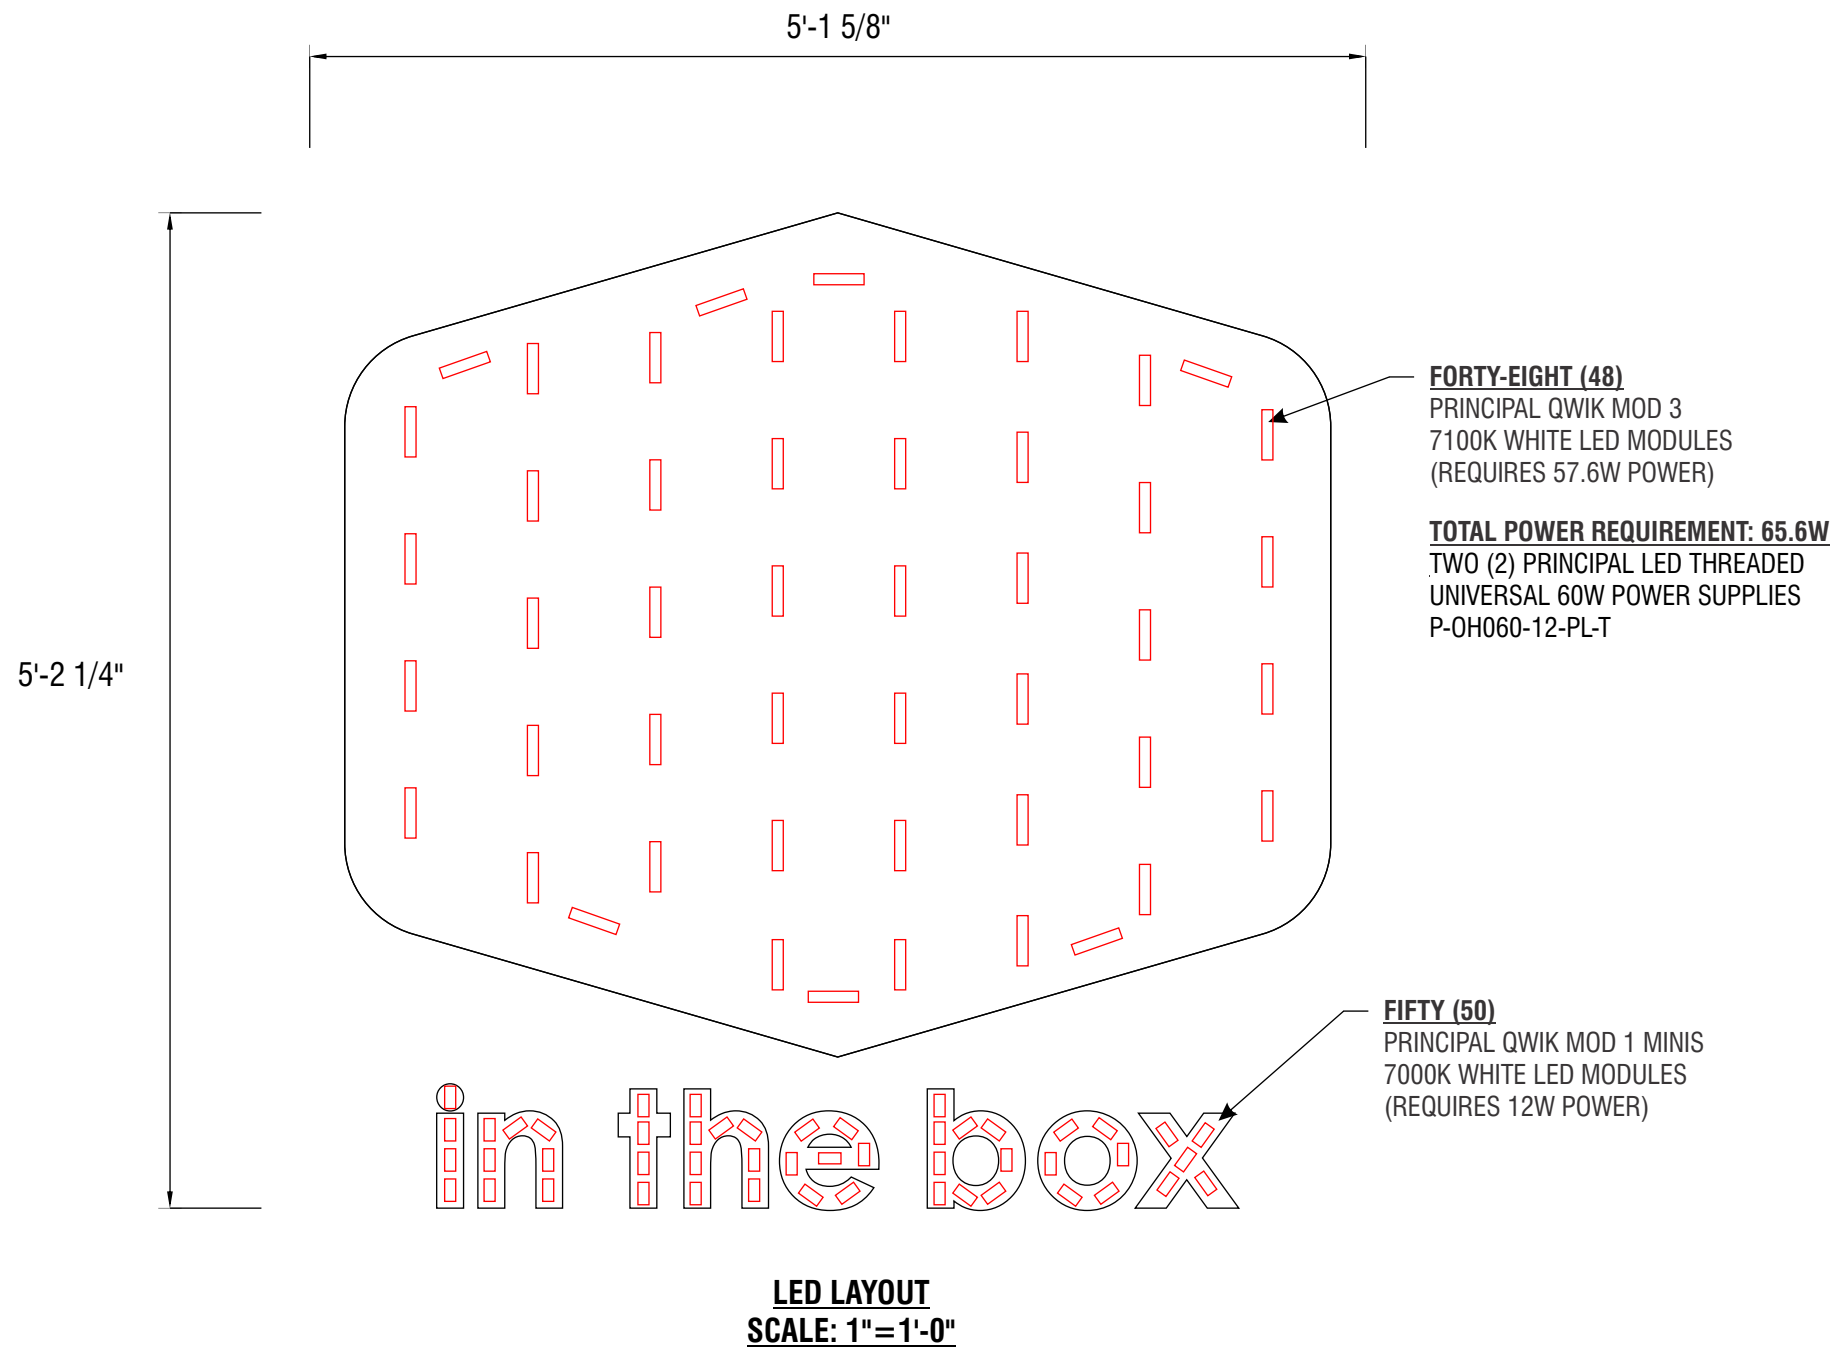

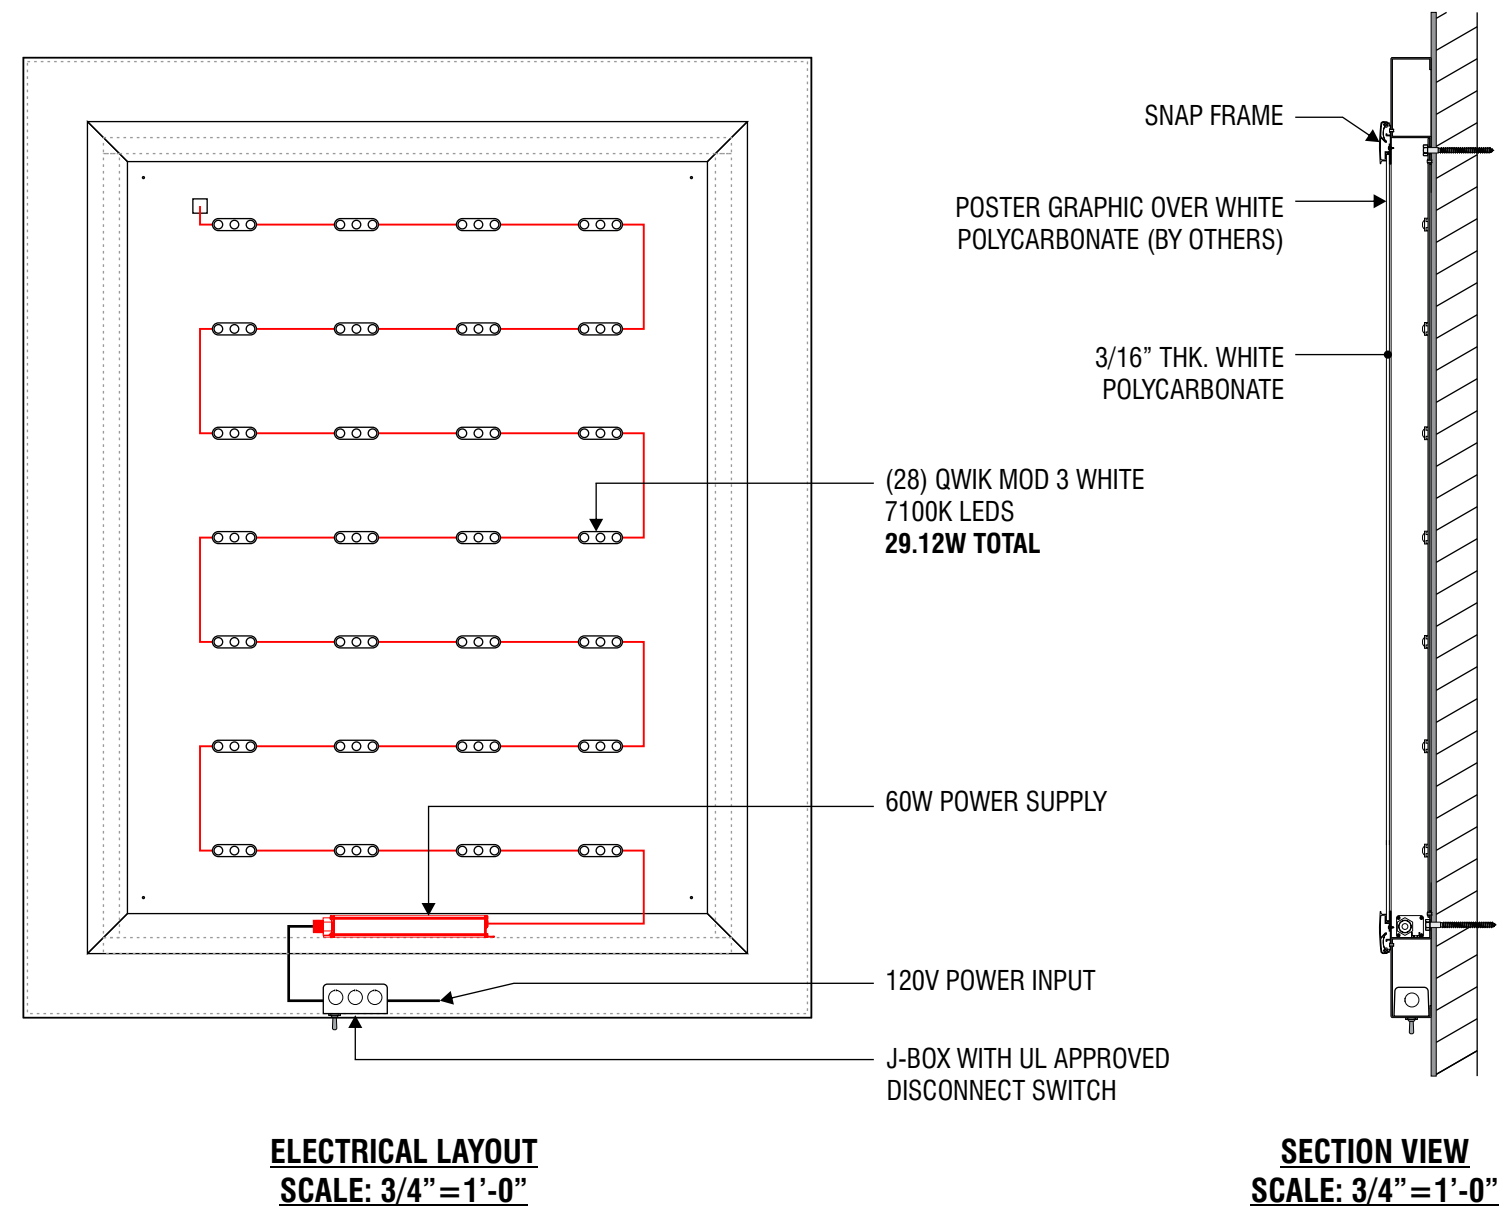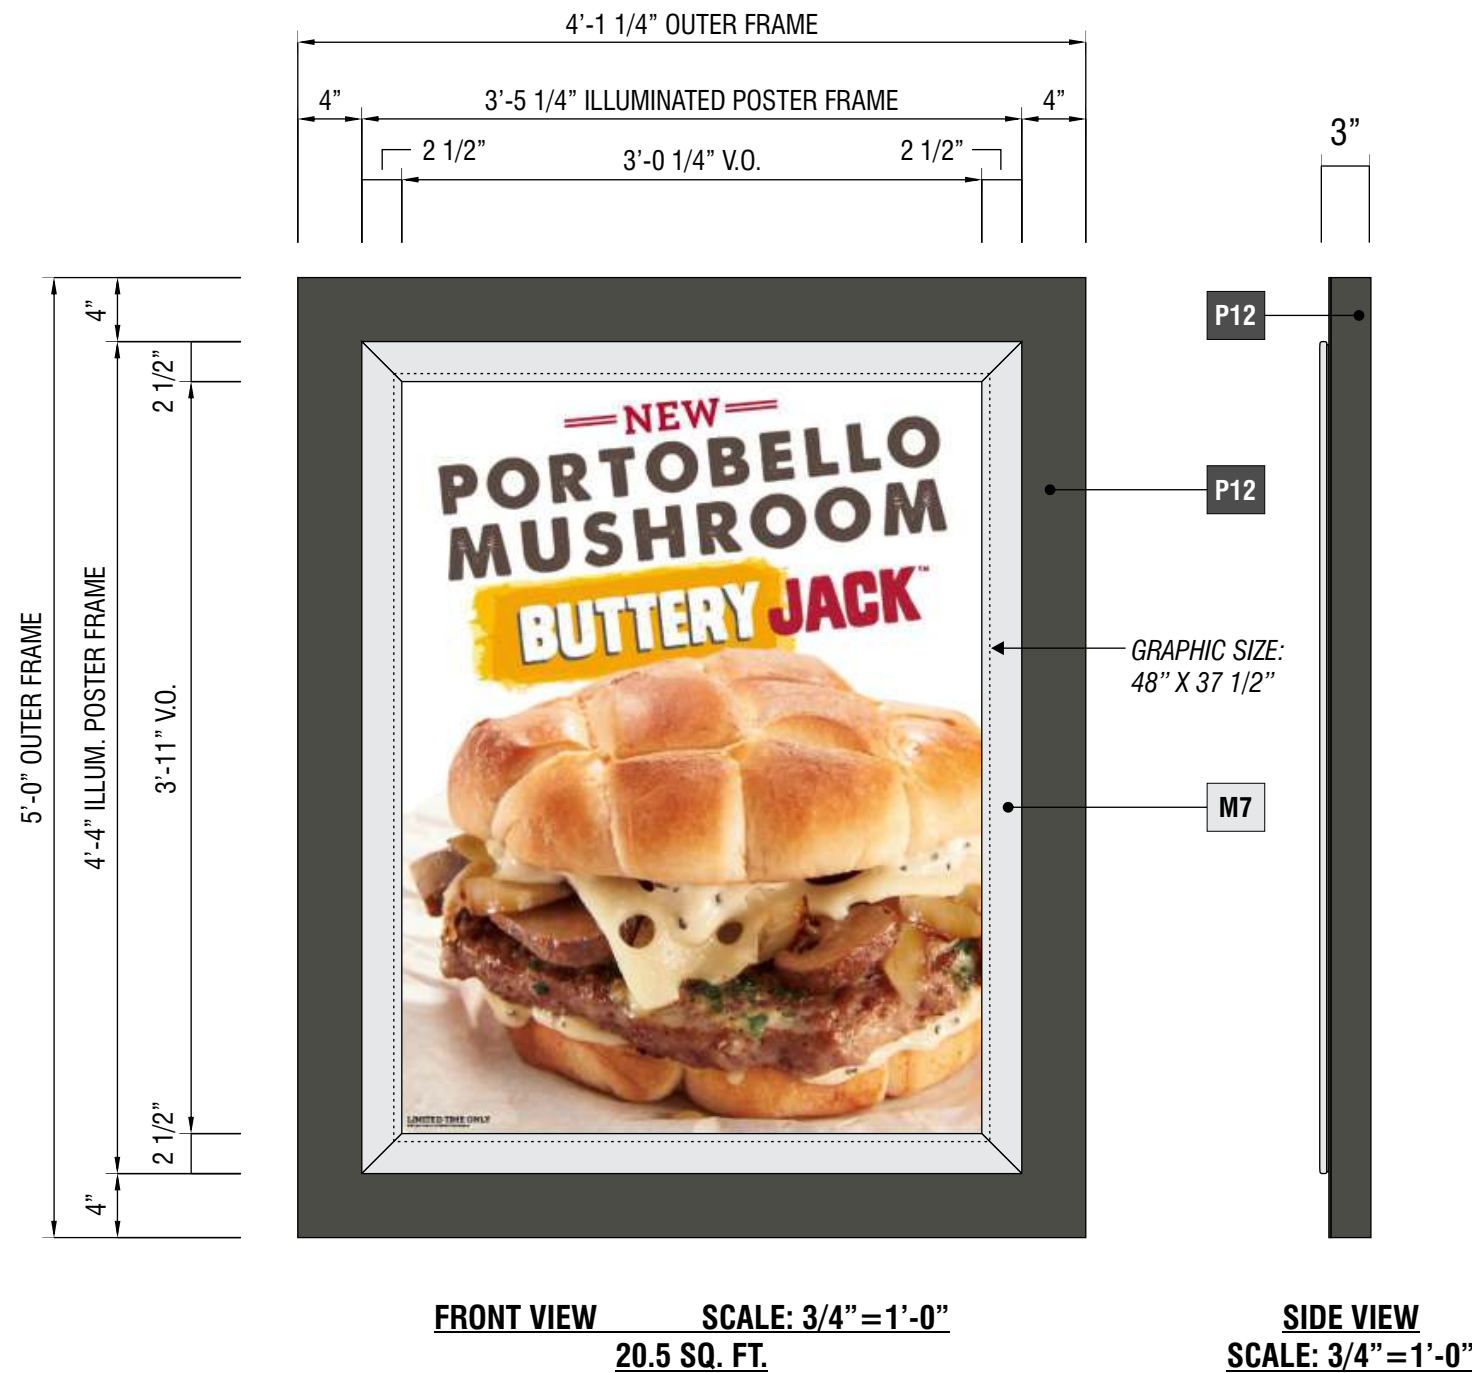

E1 E2 E3 SIGNTYPE JITB-WC-60x49-MARQUEE

MANUFACTURE AND INSTALL THREE (3) ILLUMINATED SINGLE POSTER MARQUEE PANELS
DIFFUSER: ROUTED 3/16" WHITE POLYCARBONATE WITH ATTACHED SNAP FRAME, *INSERTS BY OTHERS*
OUTER FRAME: FABRICATED .063" THICK ALUMINUM
ILLUMINATION: INTERNAL LED ILLUMINATION AND UL APPROVED DISCONNECT SWITCH

PAINT

P12 TO MATCH RAL7022 W/ SATIN FINISH
'UMBRA GREY'

MATERIALS

M7 ALUMINUM SNAP FRAME W/ CLEAR ANODIZED SATIN FINISH



4444 Federal Blvd San Diego, CA 92102
(619) 527-6100 signtech.com


JACK IN THE BOX

J5499
5133 E Washington Blvd, Commerce, CA 90040 USA

This design is the exclusive property of Signtech and cannot be reproduced in whole or in part, without their prior written approval


Sales: Bob McCarter
Project Manager: Steve Wood
Design: JMc
Engineering:

date: 7/1/25
drawing: J5499 Permit Package
revision: R1-7/8/25-JMc
project ID: JIB_5499_1

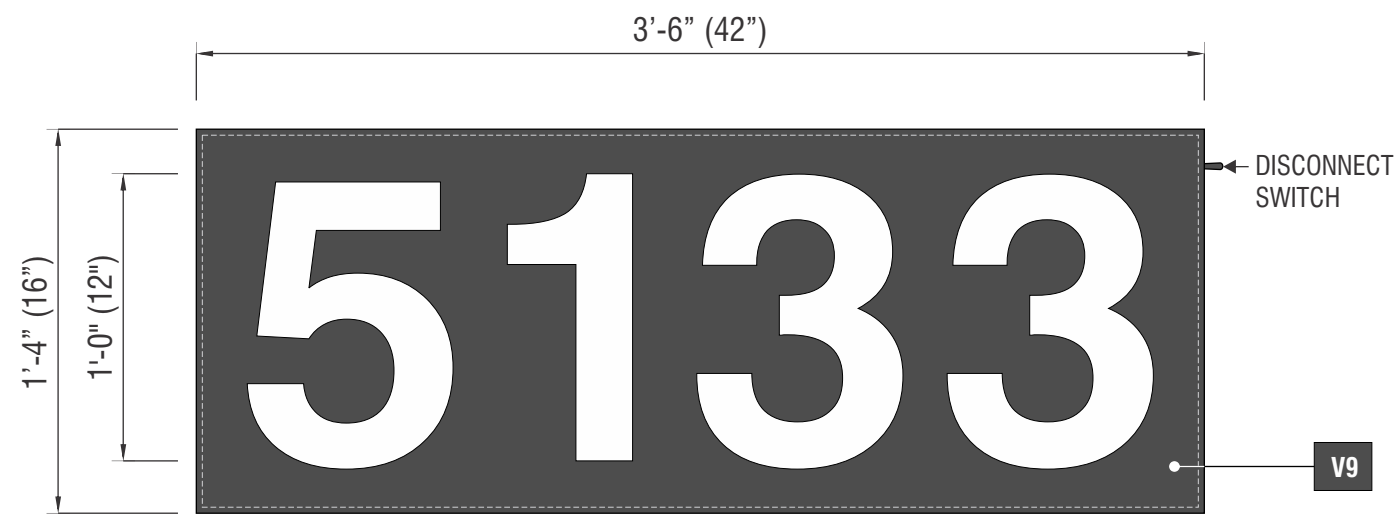


FRONT VIEW

SCALE: 1 1/2"=1'-0"

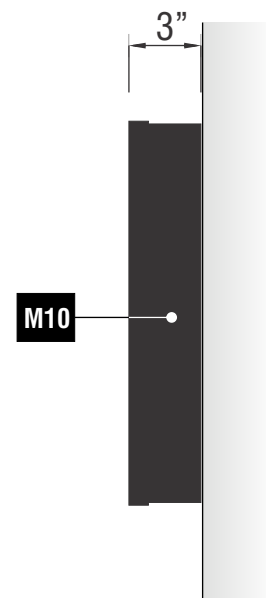


SIDE VIEW

SCALE: 1 1/2"=1'-0"

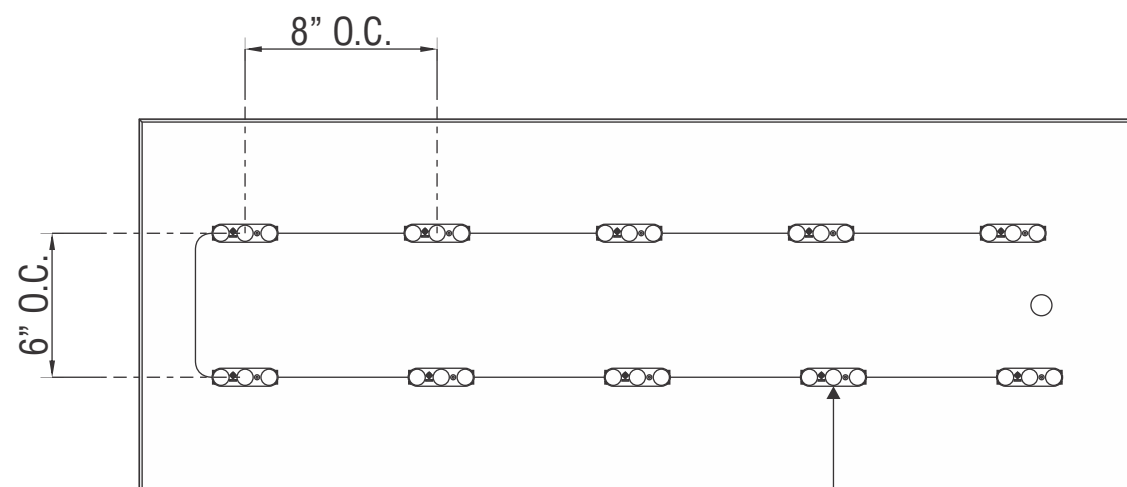

(10) PRINCIPAL QWIK MOD 3 7100K WHITE LED MODULES
1.12W PER MODULE x 10 MODULES = 11.2W

- (10) PRINCIPAL QWIK MOD 3 7100K WHITE LEDS
- (1) MEAN WELL 12V/20W (LP-V20-12) POWER SUPPLY @ 0.55 AMPS
TOTAL ELECTRICAL LOAD = 0.55 AMPS
- (1) TRANSCO (E129809) TOGGLE SWITCH DOUBLE POLE W-BOOT W/P
DISCONNECT SWITCHES REQUIRED
- (1) PAIGE 'SNAP Z' TRANS CAN.
- (1) DEDICATED 20 AMPS. x 120 VOLT x 60 Hz
CIRCUIT TO BE PROVIDED BY CUSTOMER
- UL & DATA LABELS ARE REQUIRED

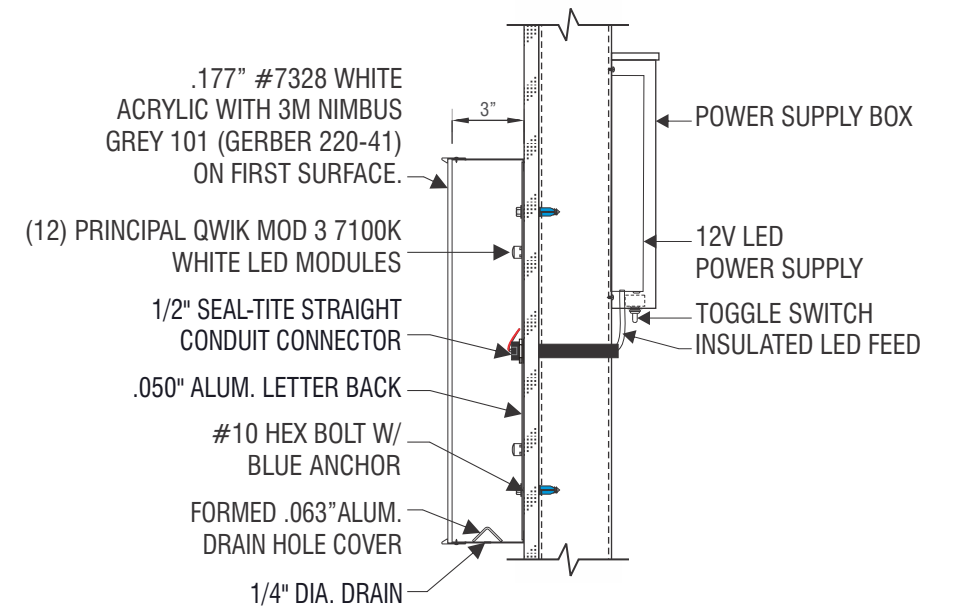

SECTION VIEW

SCALE: 1 1/2"=1'-0"

F SIGNTYPE JITB-WC-16x42-ADDRESS-5133

MANUFACTURE AND INSTALL ONE (1) PLEX FACE INTERNALLY ILLUMINATED ADDRESS CHANNEL LETTER

FACE: .177" THICK #7328 WHITE ACRYLIC WITH 3M NIMBUS GREY 101 (GERBER 220-41) ON FIRST SURFACE.

TRIMCAP : 1" BLACK JEWELITE

RETURNS: .040" x 3" DEEP PRE-PAINTED SATIN BLACK ALUM. COIL.

BACKS: .050" PRE-PAINTED WHITE ALUM.

ILLUMINATION : PRINCIPAL QWIK MOD 3 7100K WHITE

VINYL

V9 3M NIMBUS GREY 101
(GERBER 220-41)

MATERIALS

M10 3" CHANNEL LETTER COIL PRE-COATED
BLACK WITH SATIN FINISH



4444 Federal Blvd San Diego, CA 92102
(619) 527-6100 signtech.com


JACK IN THE BOX

J5499
5133 E Washington Blvd, Commerce, CA 90040 USA


This design is the exclusive property of Signtech and cannot be reproduced in whole or in part, without their prior written approval

Sales: Bob McCarter
Project Manager: Steve Wood
Design: JMc
Engineering:


date: 7/1/25
drawing: J5499 Permit Package
revision: R1-7/8/25-JMc
project ID: JIB_5499_1

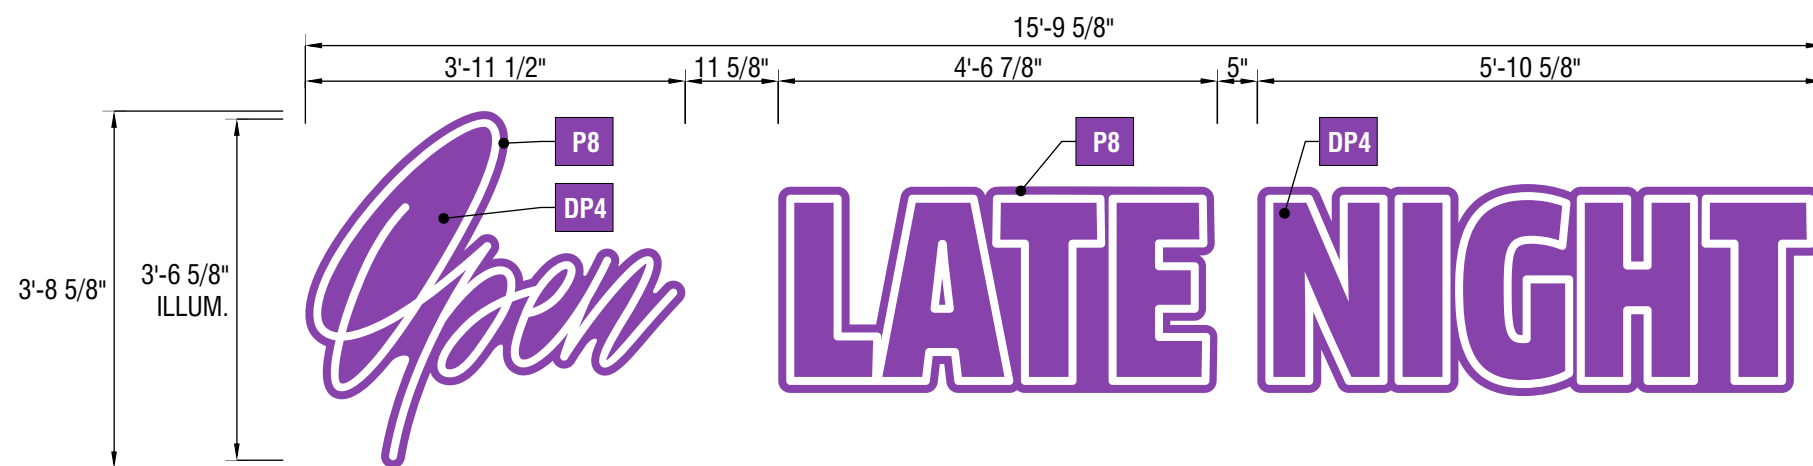

FRONT VIEW 58.76 SQ. FT. SCALE: 1/2" = 1'-0"

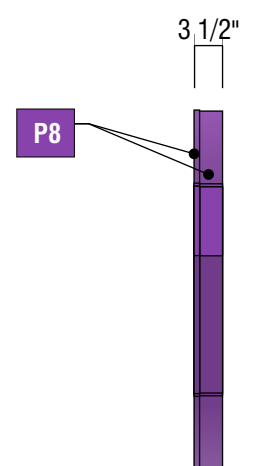

SIDE VIEW SCALE: 1/2" = 1'-0"

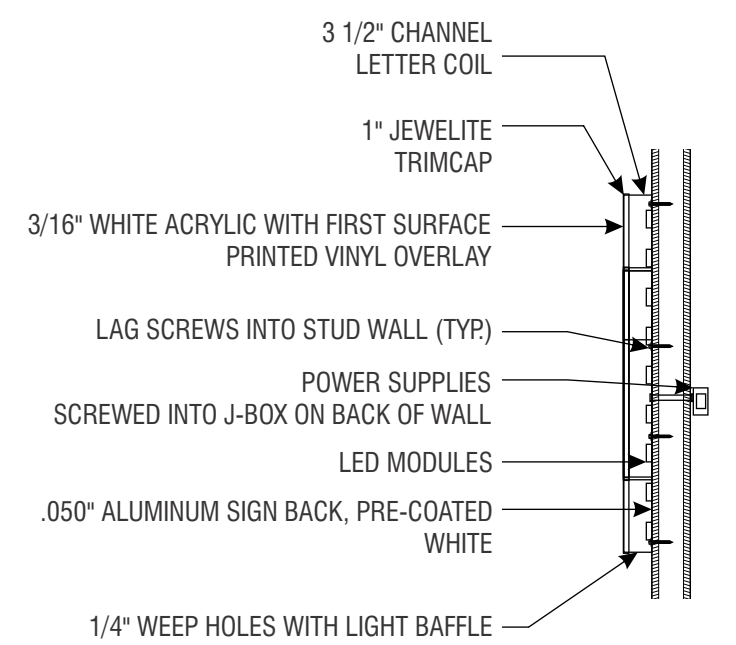

SECTION VIEW SCALE: 1/2" = 1'-0"

G SIGNTYPE JITB2-CL-44-OLN-H

MANUFACTURE AND INSTALL ONE (1) INTERNALLY ILLUMINATED WALL SIGN - "OPEN LATE NIGHT"


- "OPEN" CLOUD CABINET: .040" THICK 3 1/2" CHANNEL LETTER COIL
- "OPEN" FACE: 3/16" WHITE ACRYLIC WITH 1" JEWELITE TRIMCAP PAINTED TO MATCH RETURNS AND PRINTED VINYL OVERLAY
- "LATE NIGHT" CLOUD CABINETS: .040" THICK 3 1/2" CHANNEL LETTER COIL
- "LATE NIGHT" CLOUD FACES: 3/16" WHITE ACRYLIC WITH 1" JEWELITE TRIMCAP PAINTED TO MATCH RETURNS AND PRINTED VINYL OVERLAY
- BACKS: .050" PRE-COATED WHITE ALUMINUM
- ILLUMINATION: LED - QM2 7100K

PAINT

P8 PAINT TO MATCH SHERWIN-WILLIAMS SW6832 'IMPULSIVE PURPLE' - SATIN FINISH

DIGITAL PRINT


DP4 DIGITAL PRINT ON BLOCKOUT VINYL TO MATCH SHERWIN-WILLIAMS SW6832 'IMPULSIVE PURPLE'

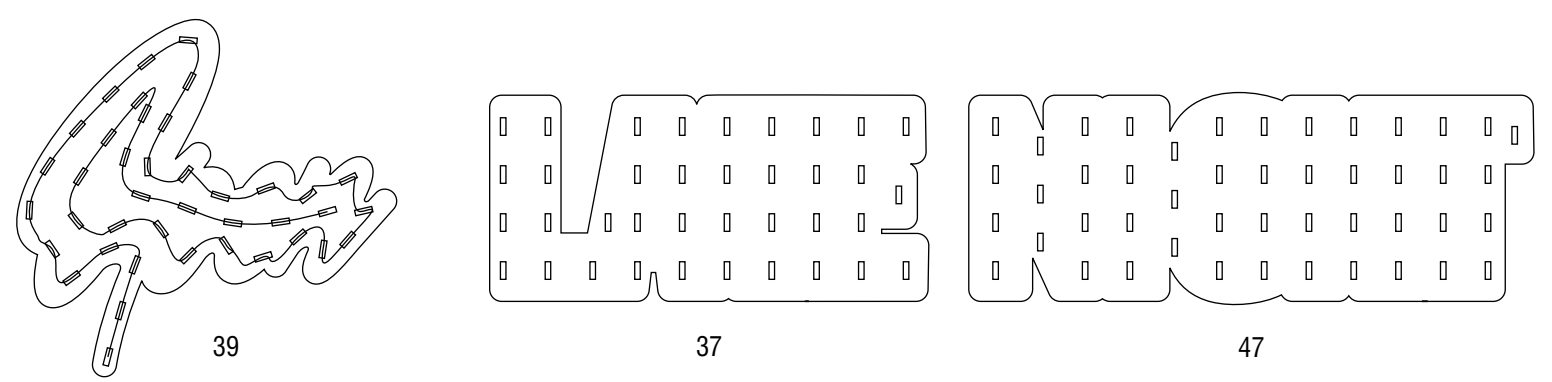



LED LAYOUT SCALE: 1/2" = 1'-0"

APPROX. LED QTY: (123) MODULES SPACED 6" APART ON CENTER

- (123) PRINCIPAL LED QWIK MOD2 SERIES TRUE WHITE 7100K (PL-QM2-TW150-P) = 73'
- (2) PRINCIPAL (P-OH060-12-HE) 60W POWER SUPPLIES @ 0.61 AMPS EACH TOTAL ELECTRICAL LOAD = 1.22 AMPS
- (1) TRANSCO (E129809) TOGGLE SWITCH W-BOOT W/P DISCONNECT SWITCHES REQUIRED
- (1) DEDICATED 20 AMPS. x 120 VOLT x 60 Hz CIRCUITS TO BE PROVIDED BY CUSTOMER
- UL & DATA LABELS ARE REQUIRED

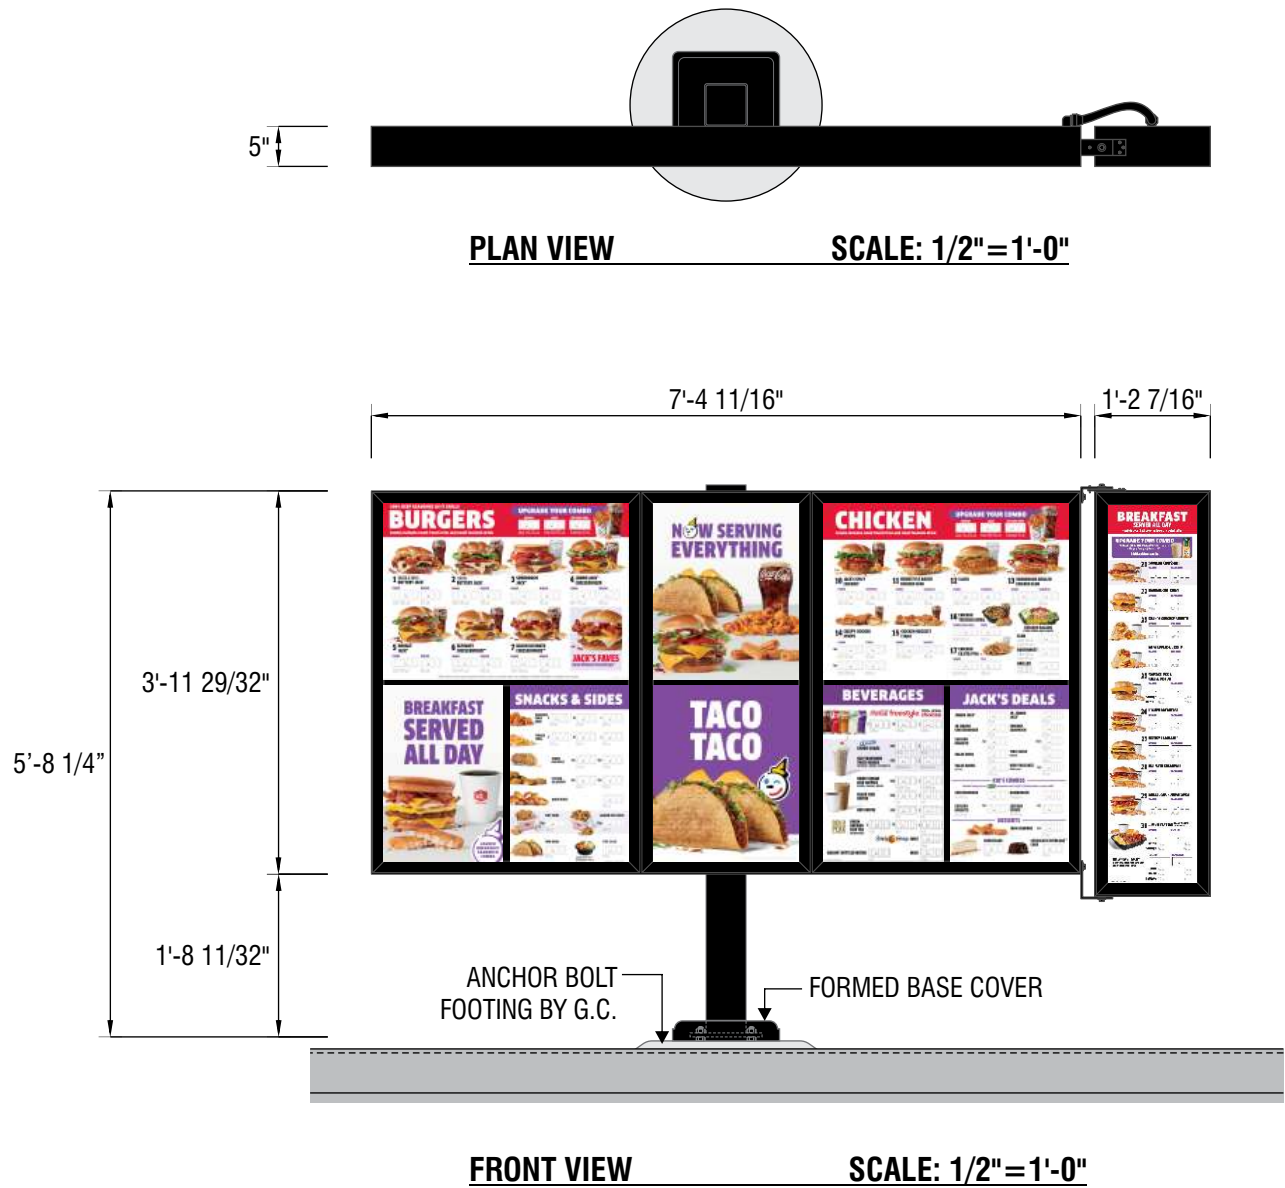

MENU GRAPHICS BY OTHERS

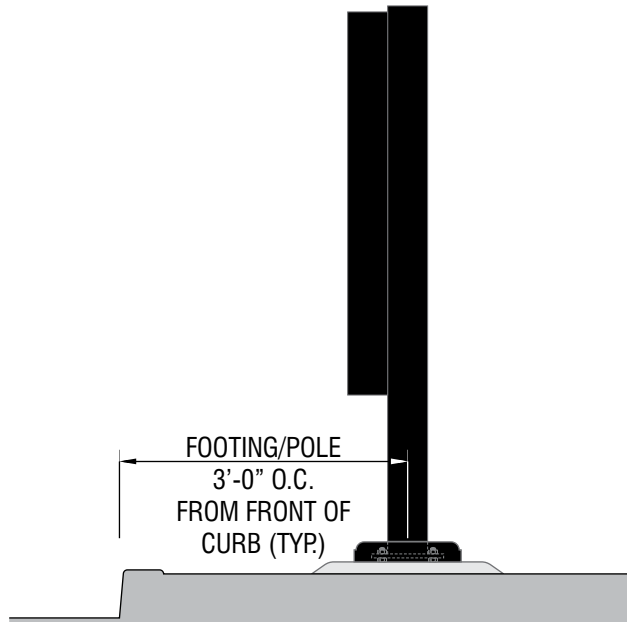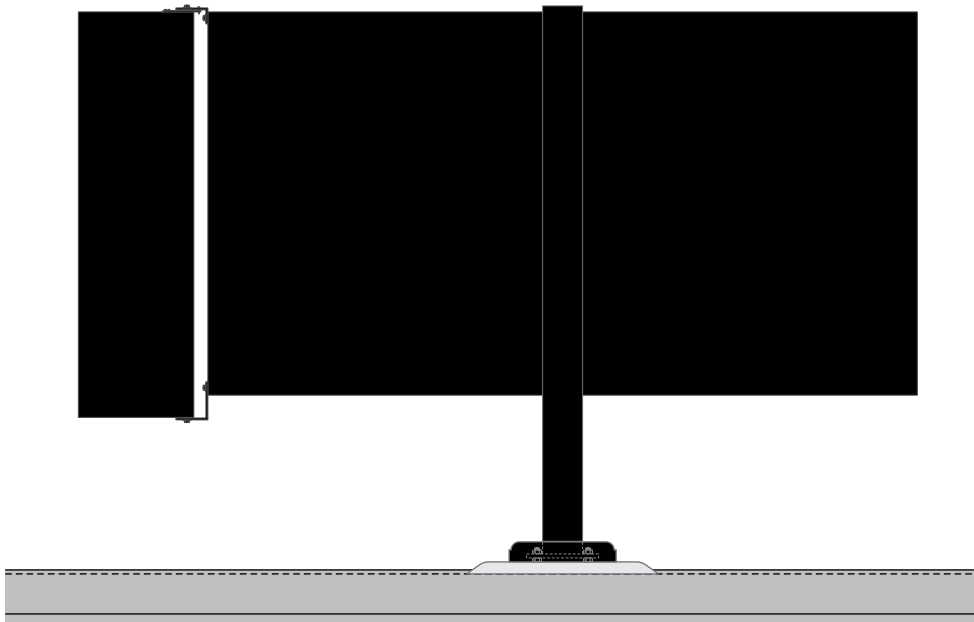

I SIGNTYPE JITB2-MB-47x88-PREVIEW

N1 SIGNTYPE JITB2-MB-EXT-50x14-BREAKFAST

MANUFACTURE AND INSTALL ONE (1) INTERNALLY ILLUMINATED EXTERIOR PREVIEW MENU DISPLAY WITH BREAKFAST EXTENDER


CABINET: EXTRUDED ALUMINUM

POLE: 5" STEEL SQUARE TUBE

PAINT

P7

TO MATCH MP SV923 BLACK
W/ SATIN FINISH

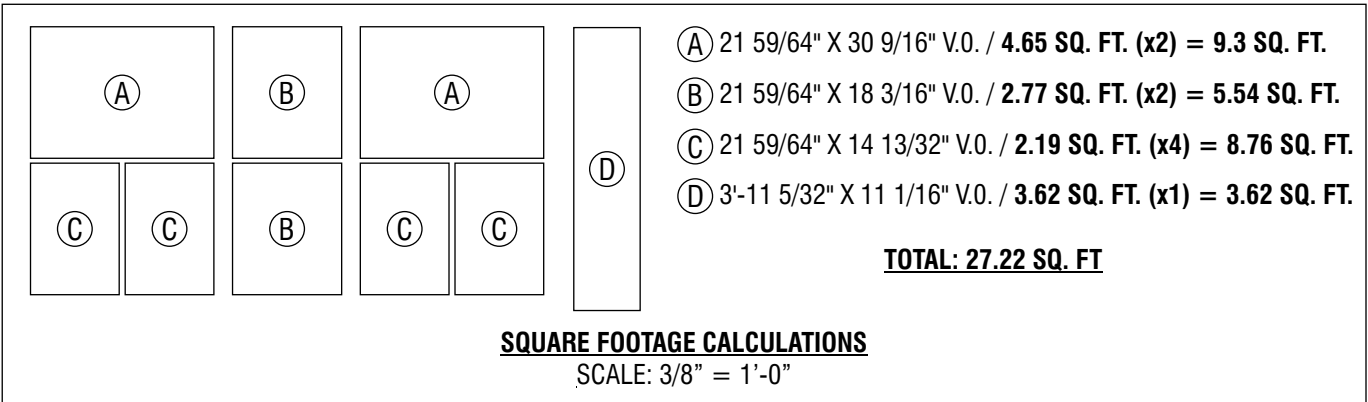

4444 Federal Blvd San Diego, CA 92102
(619) 527-6100 signtech.com

JACK IN THE BOX


J5499

5133 E Washington Blvd, Commerce, CA 90040 USA

This design is the exclusive property of Signtech and cannot be reproduced in whole or in part, without their prior written approval

Sales: Bob McCarter
Project Manager: Steve Wood
Design: JMc
Engineering:

date: 7/1/25
drawing: J5499 Permit Package
revision: R1-7/8/25-JMc
project ID: JIB_5499_1

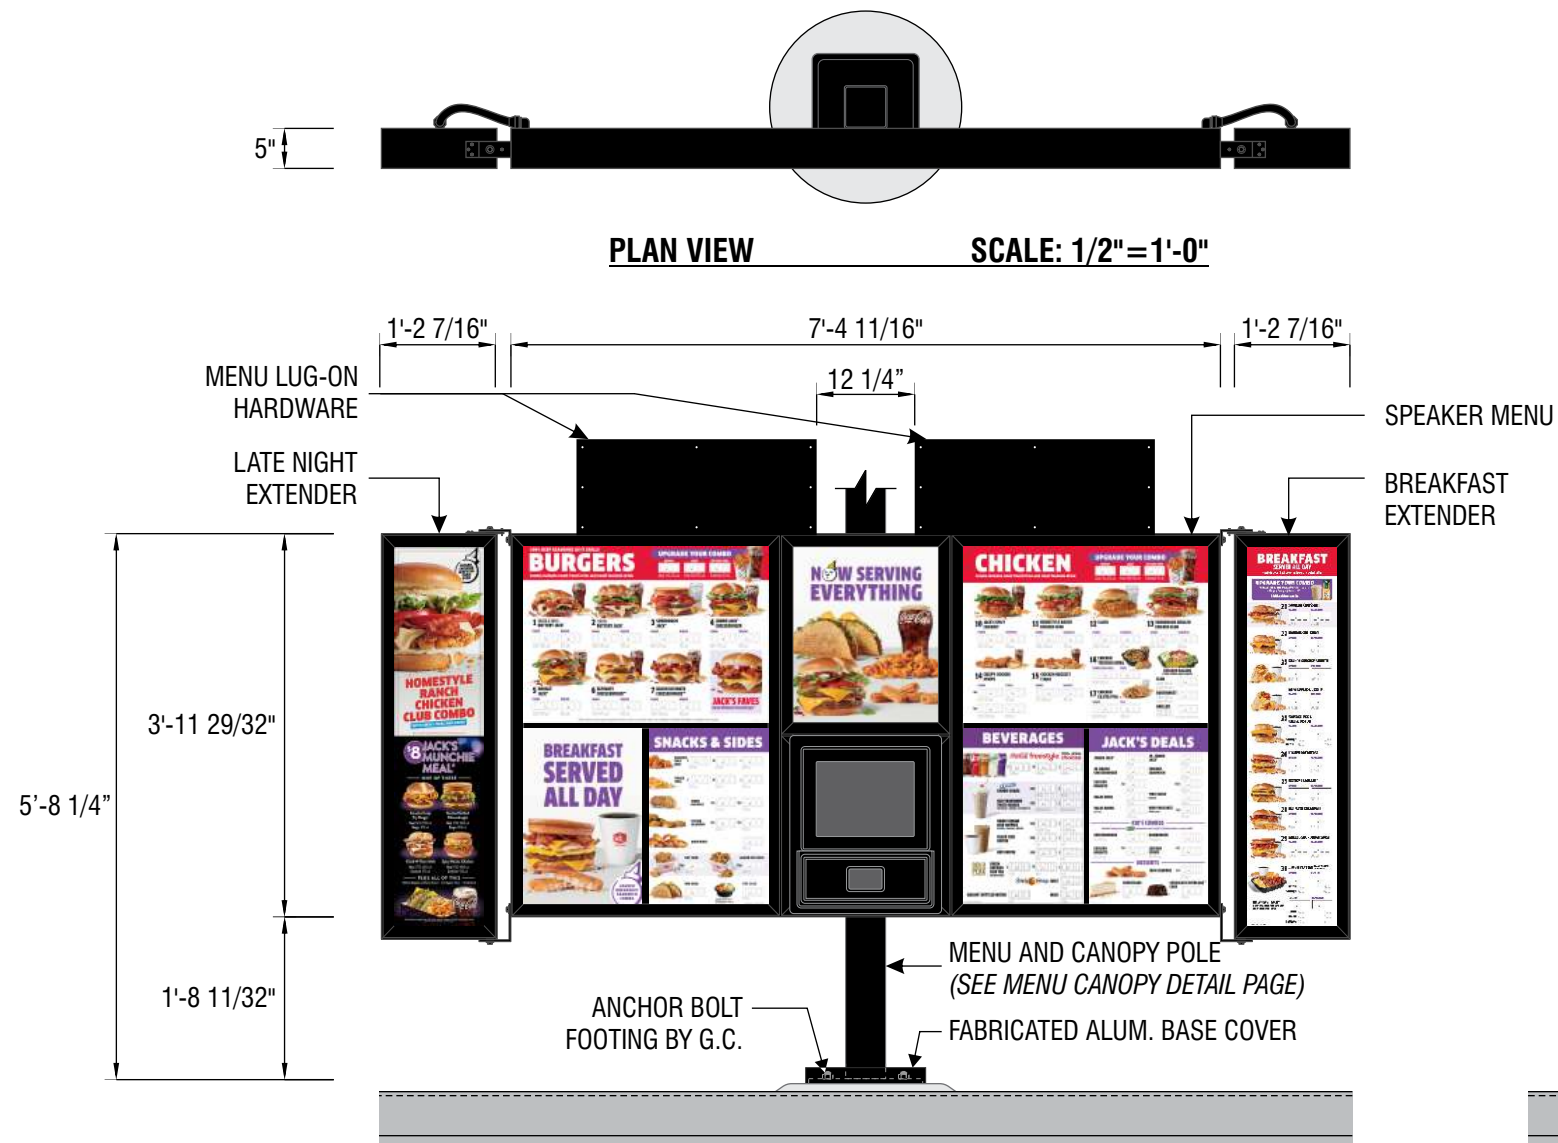

FRONT VIEW SCALE: 1/2"=1'-0"

J	SIGNTYPE	JITB2-MB-47x88-SPEAKER
N2	SIGNTYPE	JITB2-MB-EXT-50x14-BREAKFAST
N3	SIGNTYPE	JITB2-MB-EXT-50x14-LATE NIGHT
P	SIGNTYPE	JITB-MB-PNL-15x30

MANUFACTURE AND INSTALL ONE (1) INTERNALLY ILLUMINATED EXTERIOR SPEAKER MENU DISPLAY WITH BREAKFAST EXTENDER AND LATE NIGHT EXTENDER


POLE: 5" STEEL SQUARE TUBE

PAINT

P7 TO MATCH MP SV923 BLACK W/ SATIN FINISH


MENU GRAPHICS BY OTHERS

NOTE: MENU LUG-ON HARDWARE MUST BE SPACED CORRECTLY FOR GRAPHICS TO FIT.

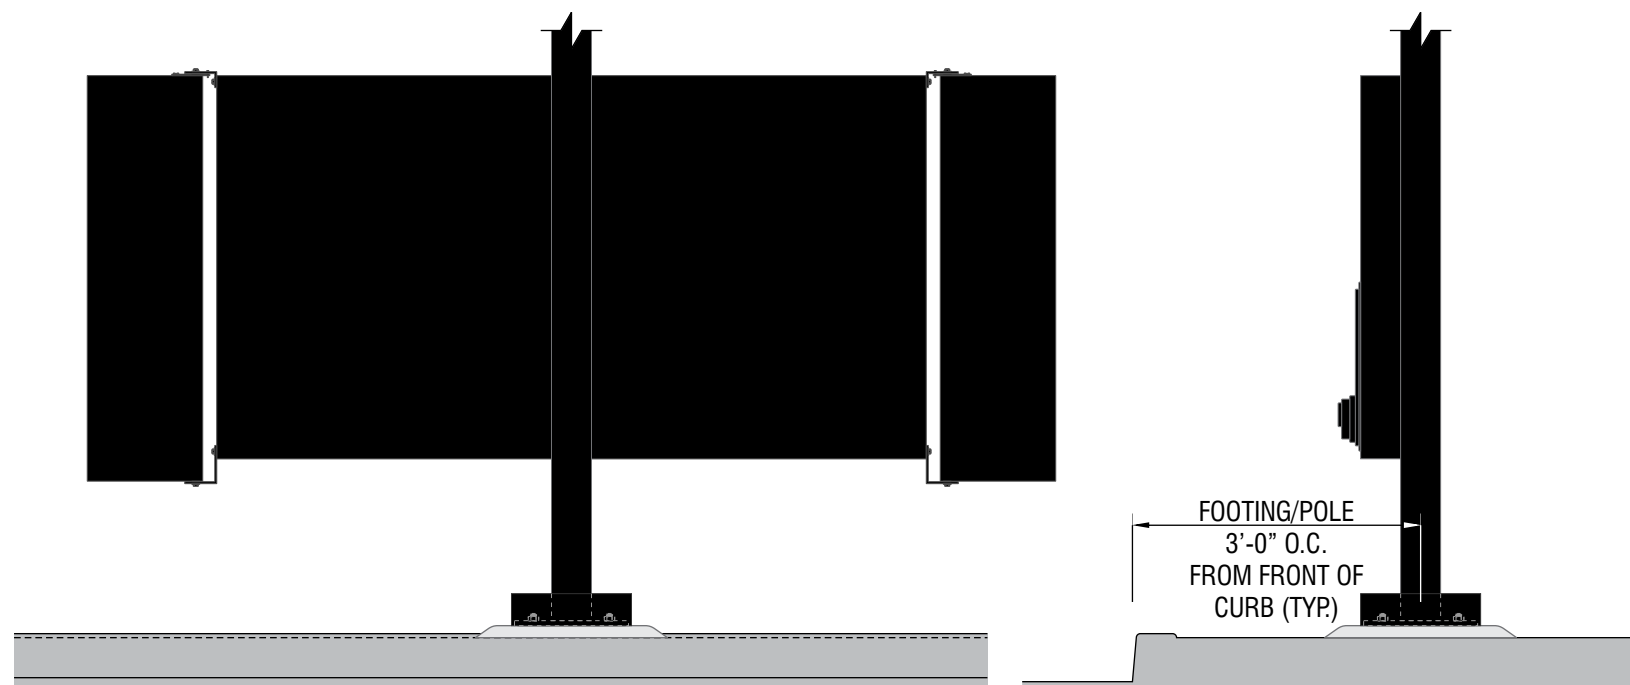

REAR VIEW SCALE: 1/2"=1'-0"

SIDE VIEW SCALE: 1/2"=1'-0"

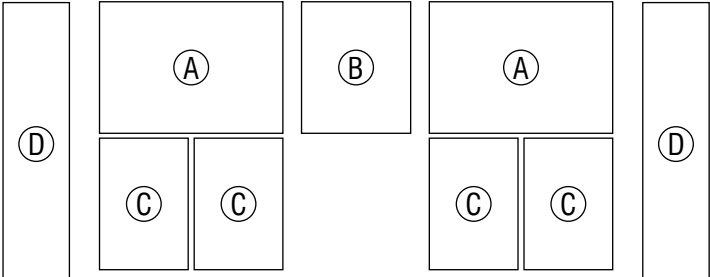	A		B		A						
	C				C						
							① 21 59/64" X 30 9/16" V.O. / 4.65 SQ. FT. (x2) = 9.3 SQ. FT.				
							② 21 59/64" X 18 3/16" V.O. / 2.77 SQ. FT. (x1) = 2.77 SQ. FT.				
							③ 21 59/64" X 14 13/32" V.O. / 2.19 SQ. FT. (x4) = 8.76 SQ. FT.				
							④ 3'-11 5/32" X 11 1/16" V.O. / 3.62 SQ. FT. (x2) = 7.24 SQ. FT.				
							<u>TOTAL: 28.07 SQ. FT</u>				
							<u>SQUARE FOOTAGE CALCULATIONS</u> SCALE: 3/8" = 1'-0"				



4444 Federal Blvd San Diego, CA 92102
(619) 527-6100 signtech.com


JACK IN THE BOX

J5499
5133 E Washington Blvd, Commerce, CA 90040 USA

This design is the exclusive property of Signtech and cannot be reproduced in whole or in part, without their prior written approval

Sales: Bob McCarter
Project Manager: Steve Wood
Design: JMc
Engineering:

date: 7/1/25
drawing: J5499 Permit Package
revision: R1-7/8/25-JMc
project ID: JIB_5499_1

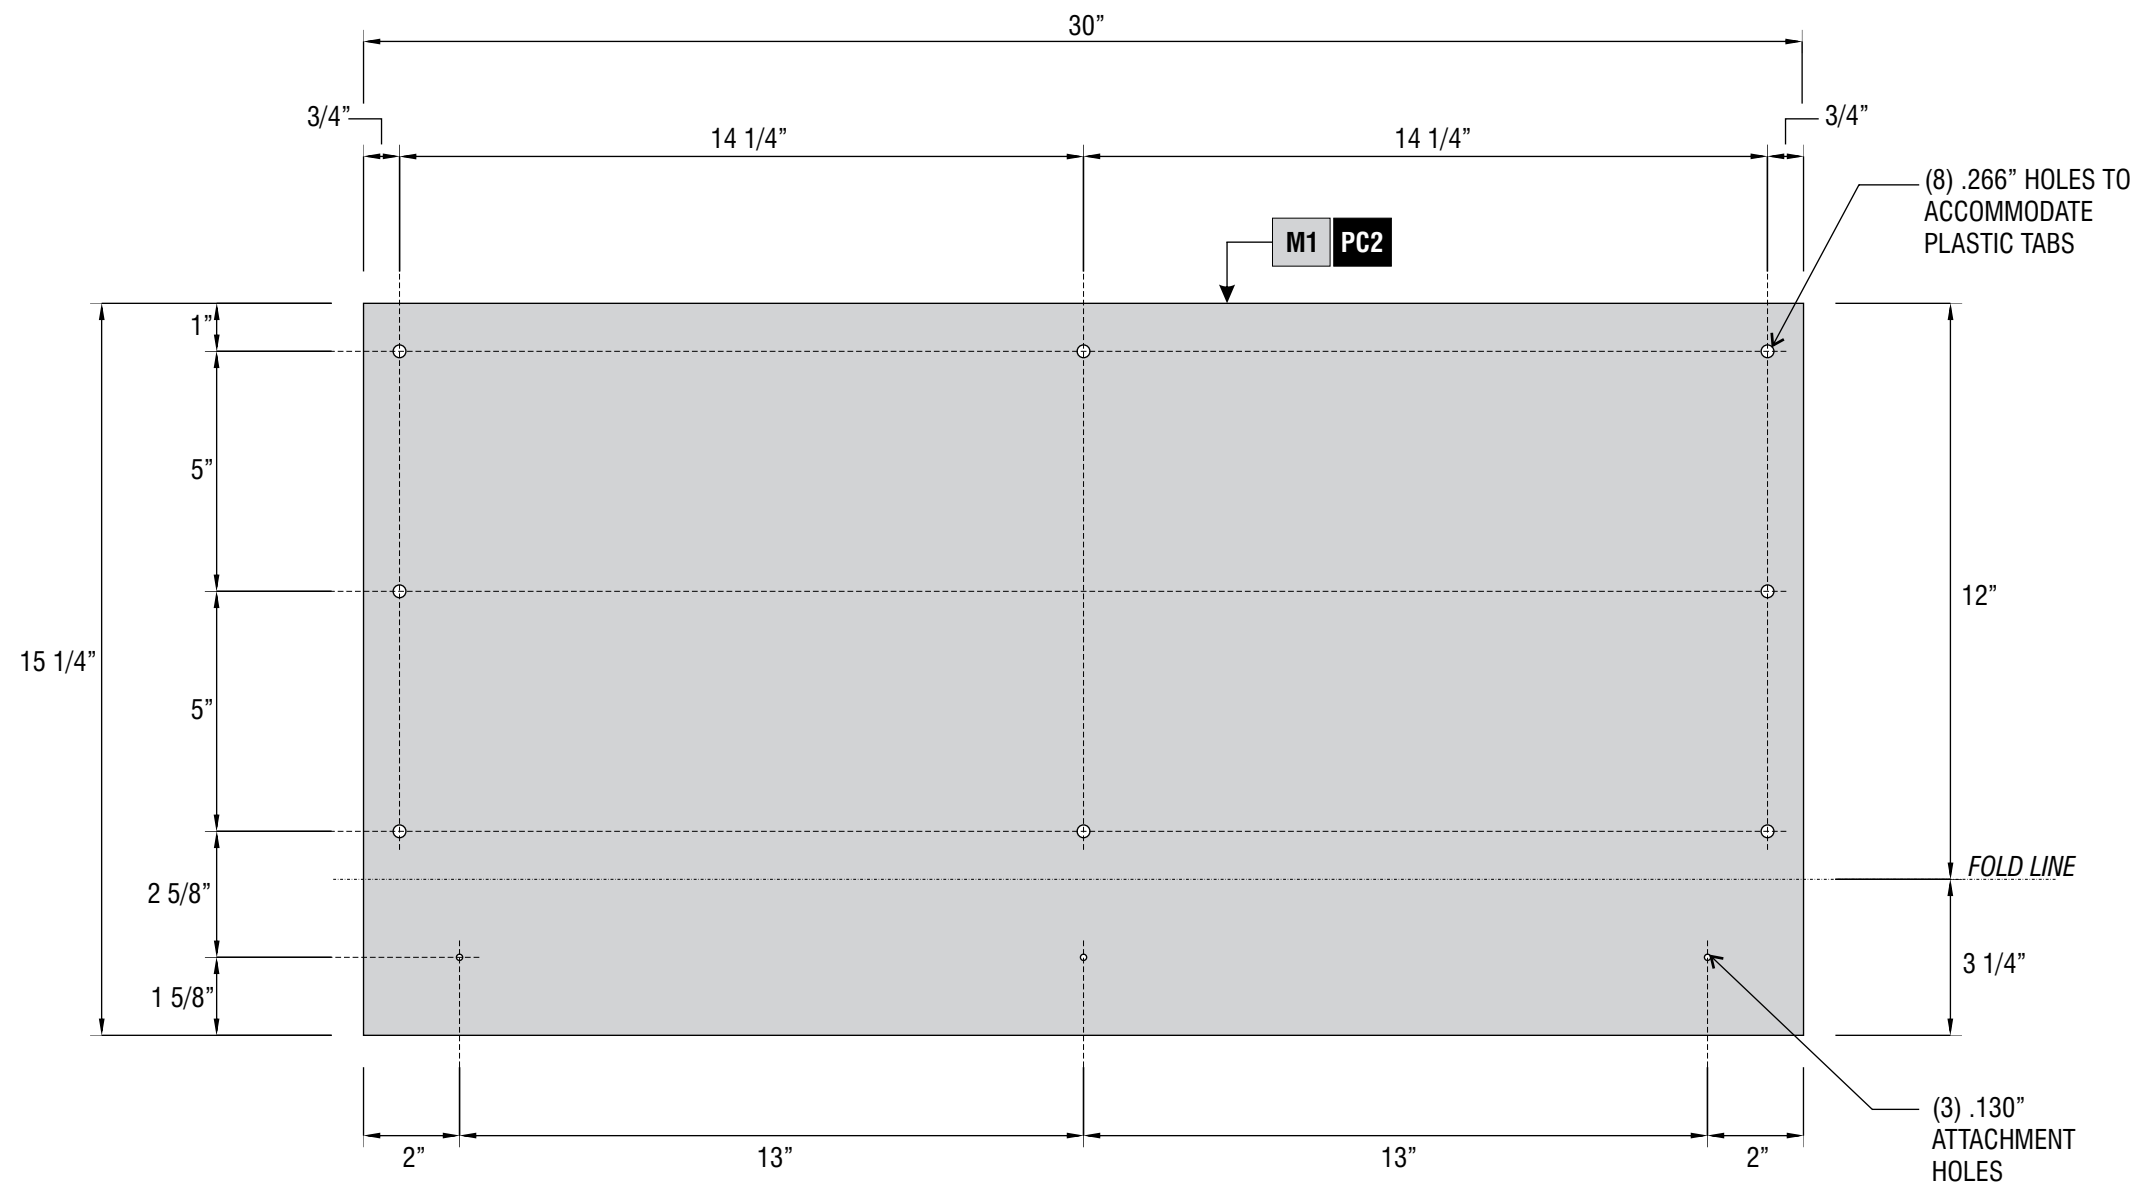

FRONT VIEW (BEFORE FOLD)

SCALE: 3"=1'-0"

P SIGNTYPE JTB-MB-PNL-15x30

MANUFACTURE AND INSTALL TWO (2) MENU LUG-ON HARDWARE PANEL
BRAKE-FORMED .080" ALUMINUM

MATERIALS


M1 .080" ALUMINUM

PAINT

P7 TO MATCH MP SV923 BLACK
W/ SATIN FINISH

NOTE:
MENU BOARD LUG-ON HARDWARE
ATTACHED TO CABINET W/ (3) 5/16"
#10 TEK SCREWS

END VIEW (FOLDED)
SCALE: 3"=1'-0"

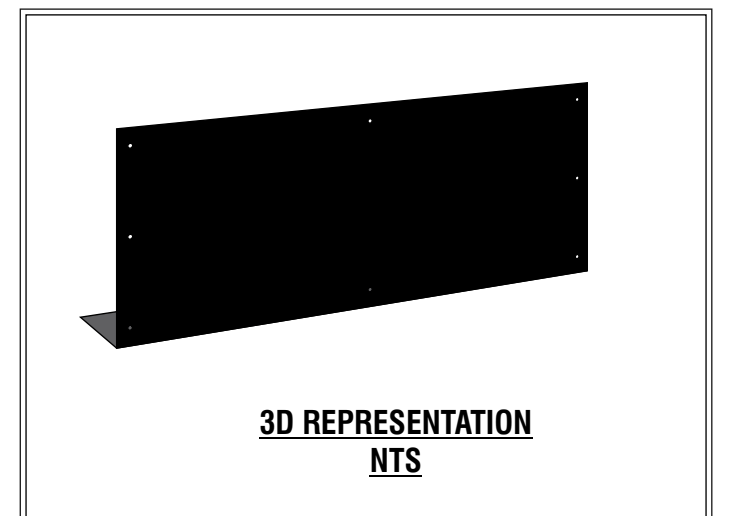

3D REPRESENTATION
NTS



4444 Federal Blvd San Diego, CA 92102
(619) 527-6100 signtech.com


JACK IN THE BOX

J5499
5133 E Washington Blvd, Commerce, CA 90040 USA


This design is the exclusive property of Signtech and cannot be reproduced in whole or in part, without their prior written approval

Sales: Bob McCarter
Project Manager: Steve Wood
Design: JMc
Engineering:


date: 7/1/25
drawing: J5499 Permit Package
revision: R1-7/8/25-JMc
project ID: JIB_5499_1

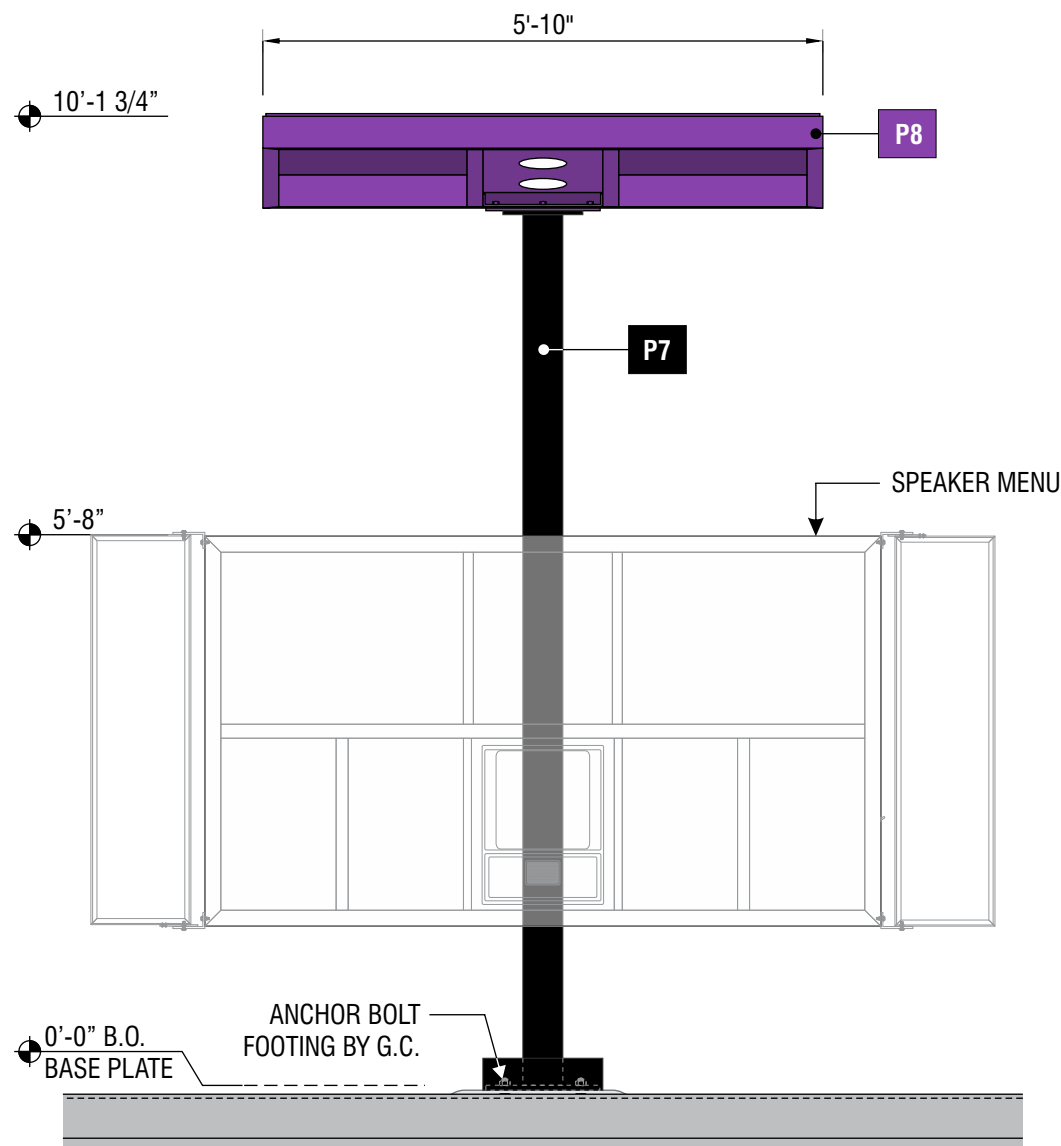


FRONT VIEW SCALE: 1/2" = 1'-0"

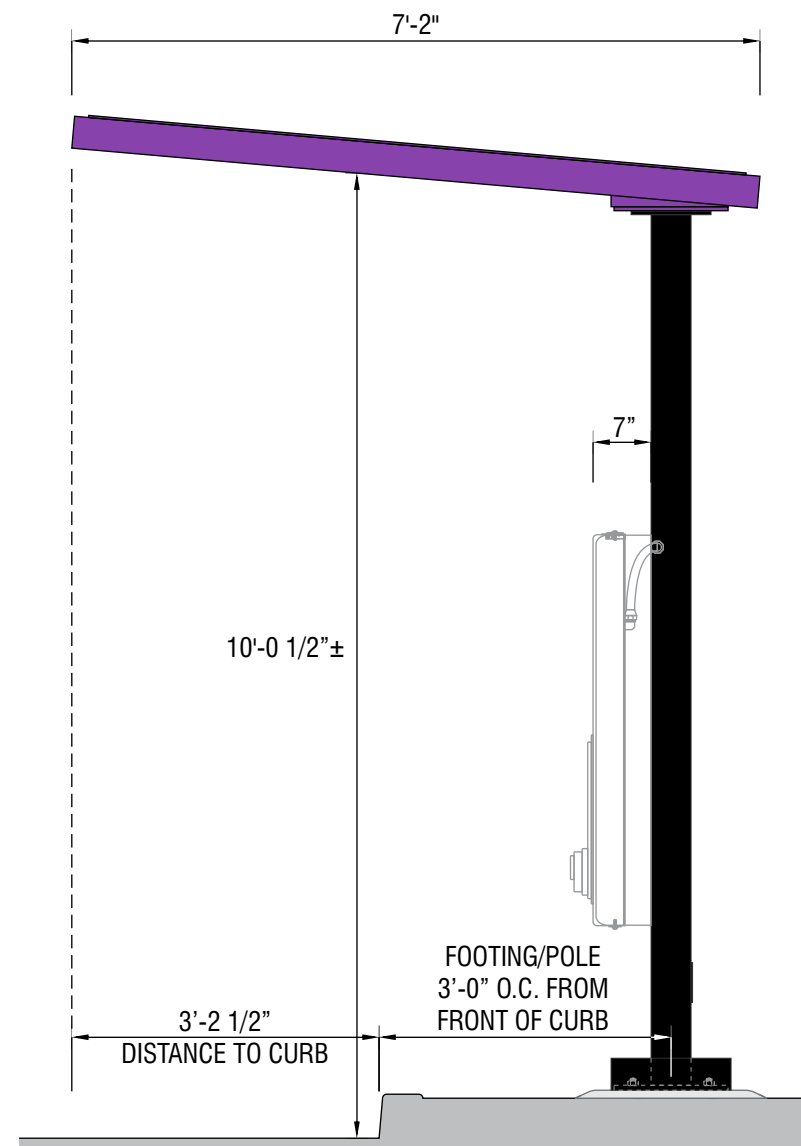


SIDE VIEW SCALE: 1/2" = 1'-0"

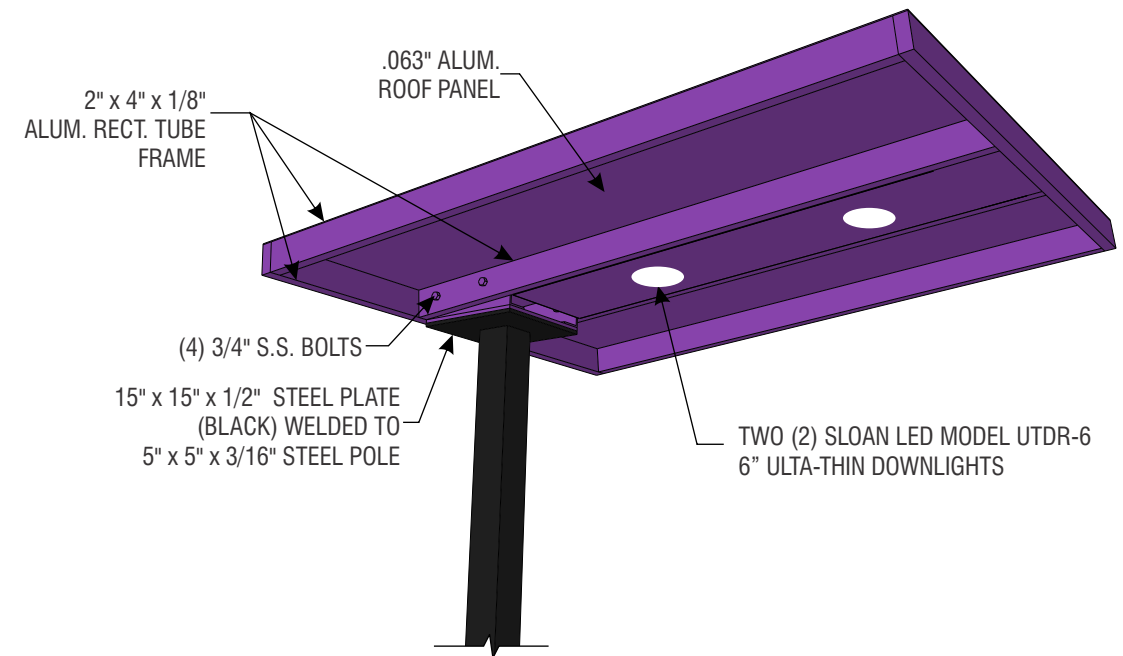


3-D RENDERING NTS

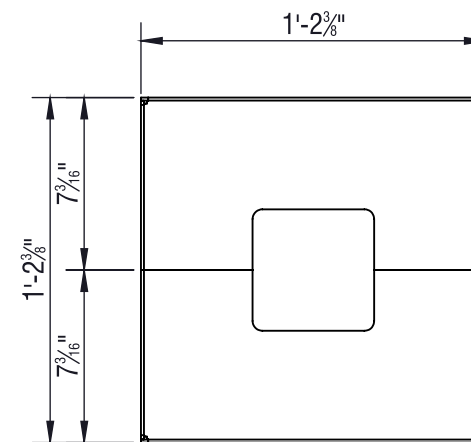


TOP VIEW

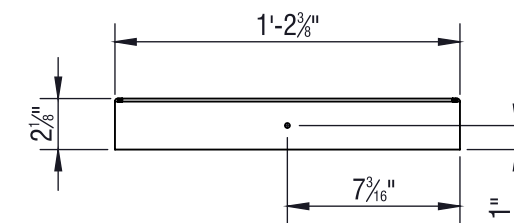

FRONT VIEW

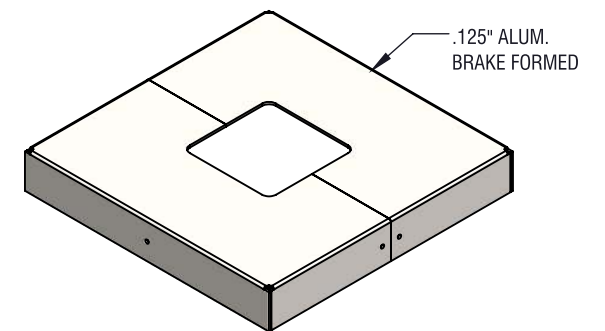

ISOMETRIC VIEW

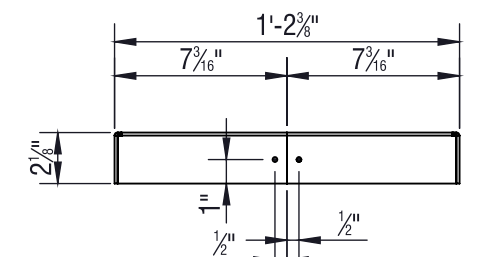

SIDE VIEW

BASE PLATE COVER DETAILS SCALE: 1 1/2" = 1'-0"

K SIGNTYPE JITB2-CAN-70x86x121-P

MANUFACTURE AND INSTALL ONE (1) MENU WEATHER CANOPY

CANOPY: ALUMINUM RECT. TUBE FRAME WITH ALUMINUM ROOF AND ALUMINUM LAMP ENCLOSURE

POLE: 5"x5" STEEL SQUARE TUBE

LAMP: TWO (2) SLOAN LED MODEL UTDR-6 6" ULTA-THIN DOWNLIGHTS - 4000K WHITE

PAINT

P7 TO MATCH MP SV923 BLACK W/ SATIN FINISH

P8 PAINT TO MATCH SHERWIN-WILLIAMS SW6832 'IMPULSIVE PURPLE' - SATIN FINISH



4444 Federal Blvd San Diego, CA 92102
(619) 527-6100 signtech.com






JACK IN THE BOX



J5499
5133 E Washington Blvd, Commerce, CA 90040 USA

This design is the exclusive property of Signtech and cannot be reproduced in whole or in part, without their prior written approval

Sales: Bob McCarter
Project Manager: Steve Wood
Design: JMc
Engineering:

date: 7/1/25
drawing: J5499 Permit Package
revision: R1-7/8/25-JMc
project ID: JIB_5499_1

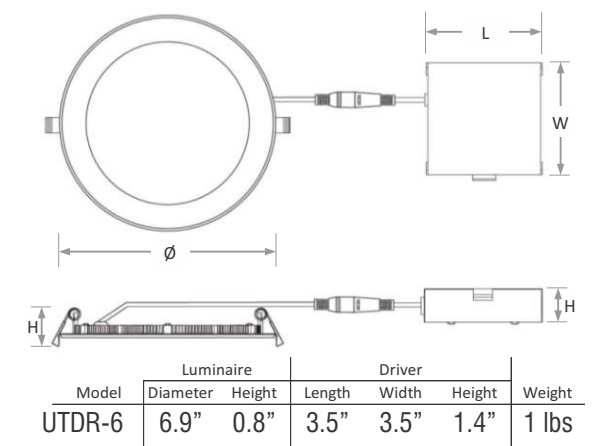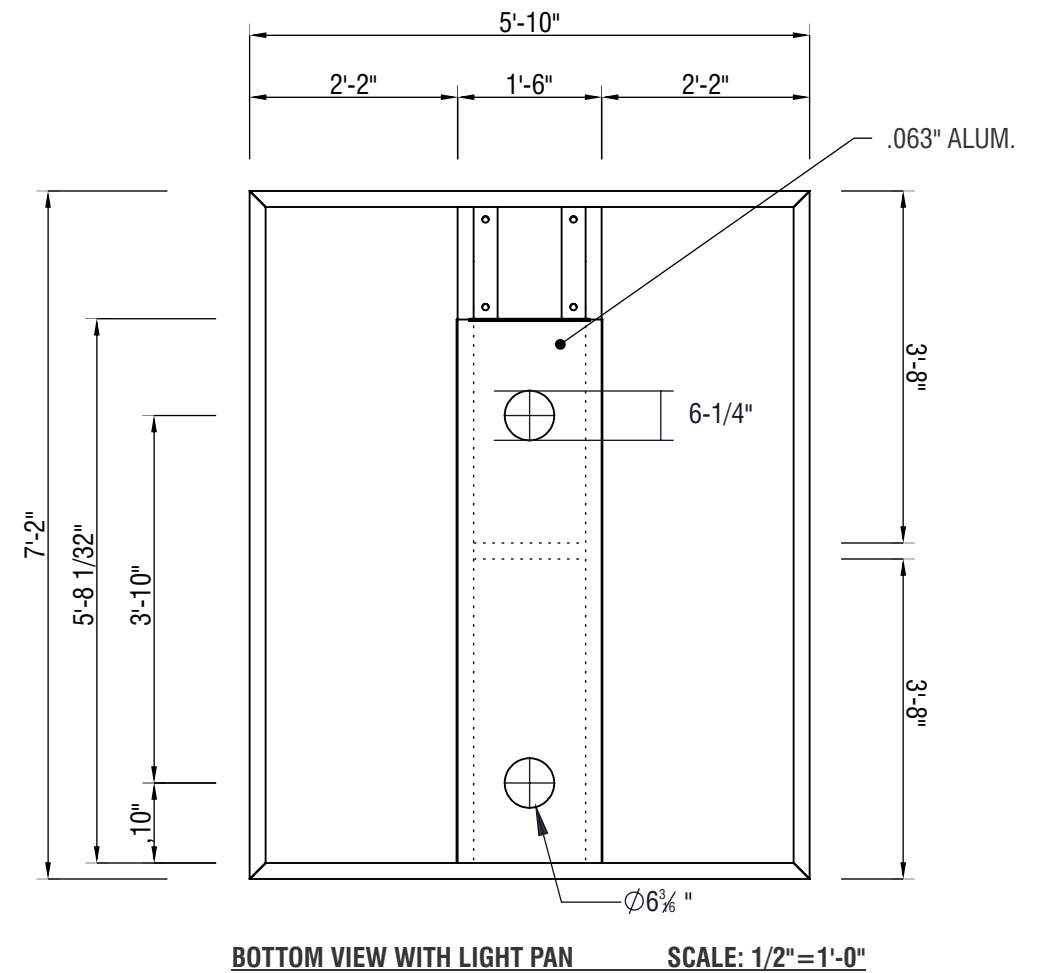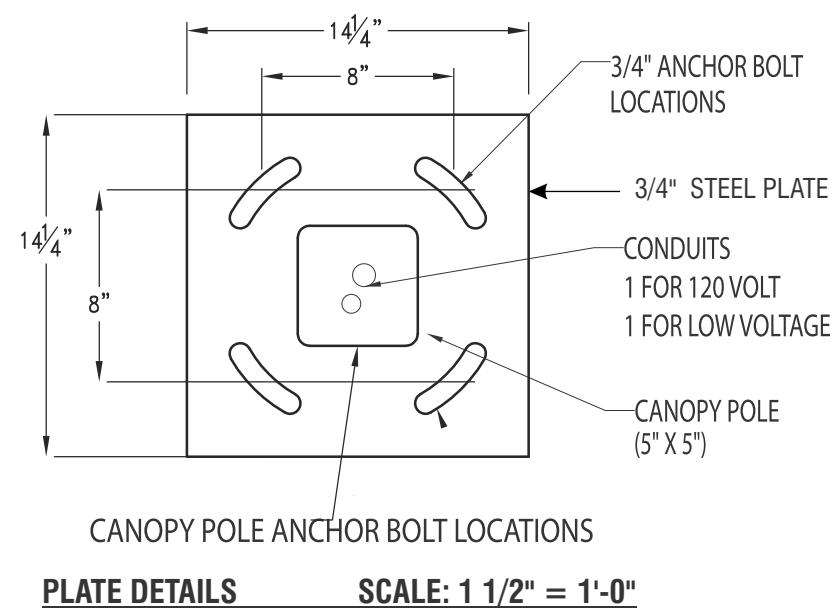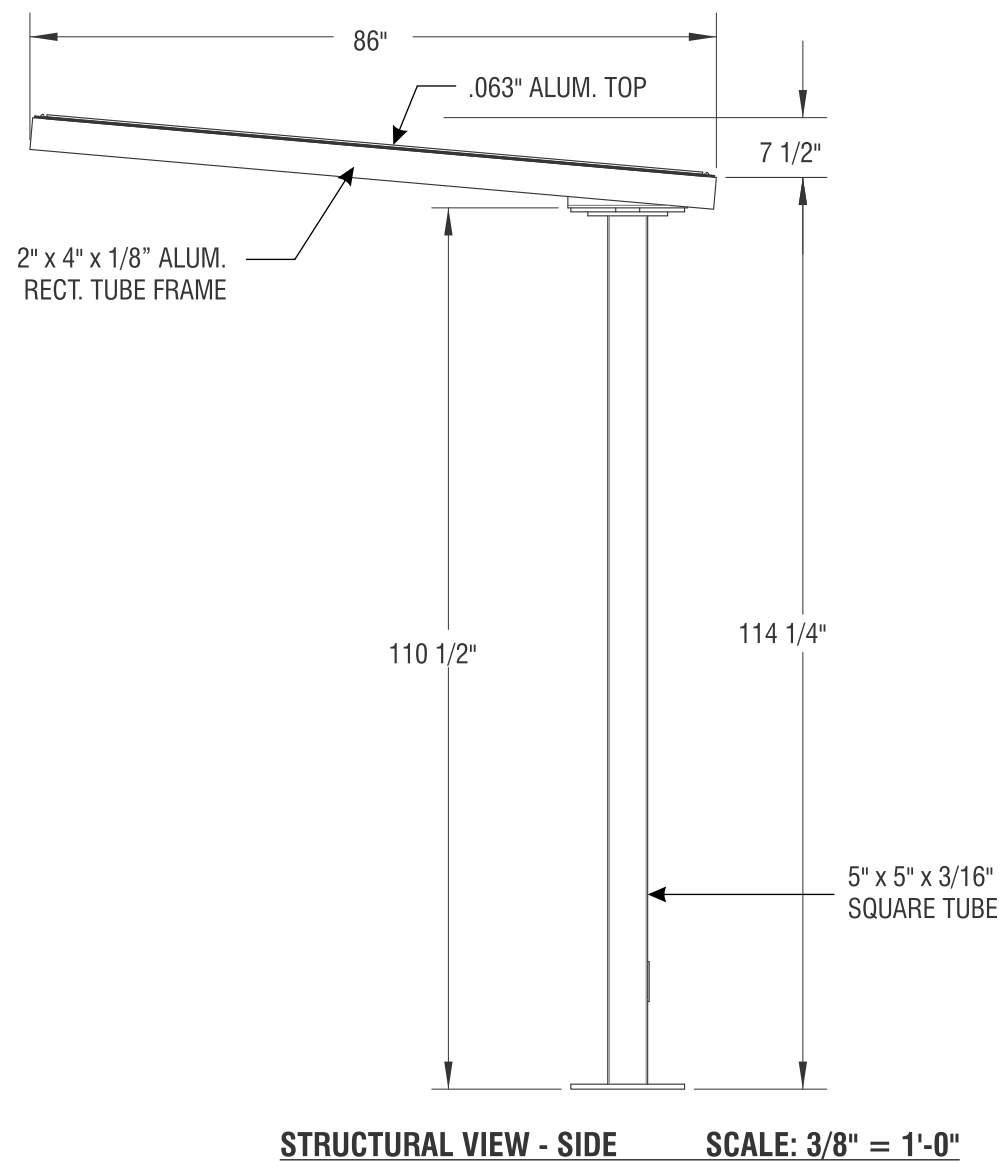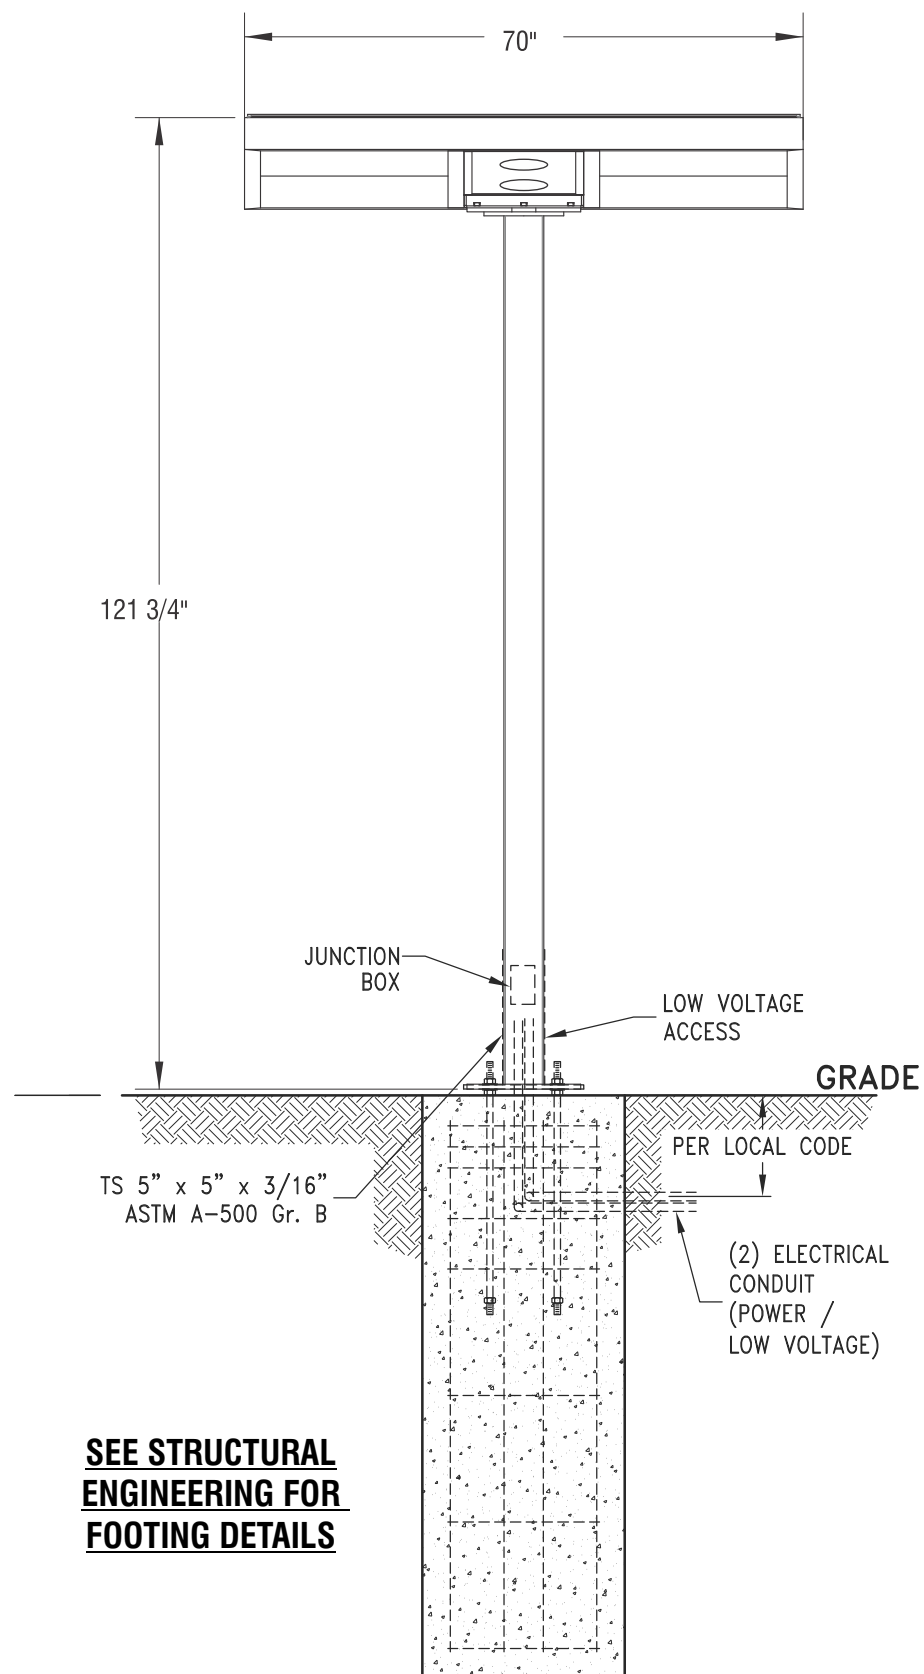

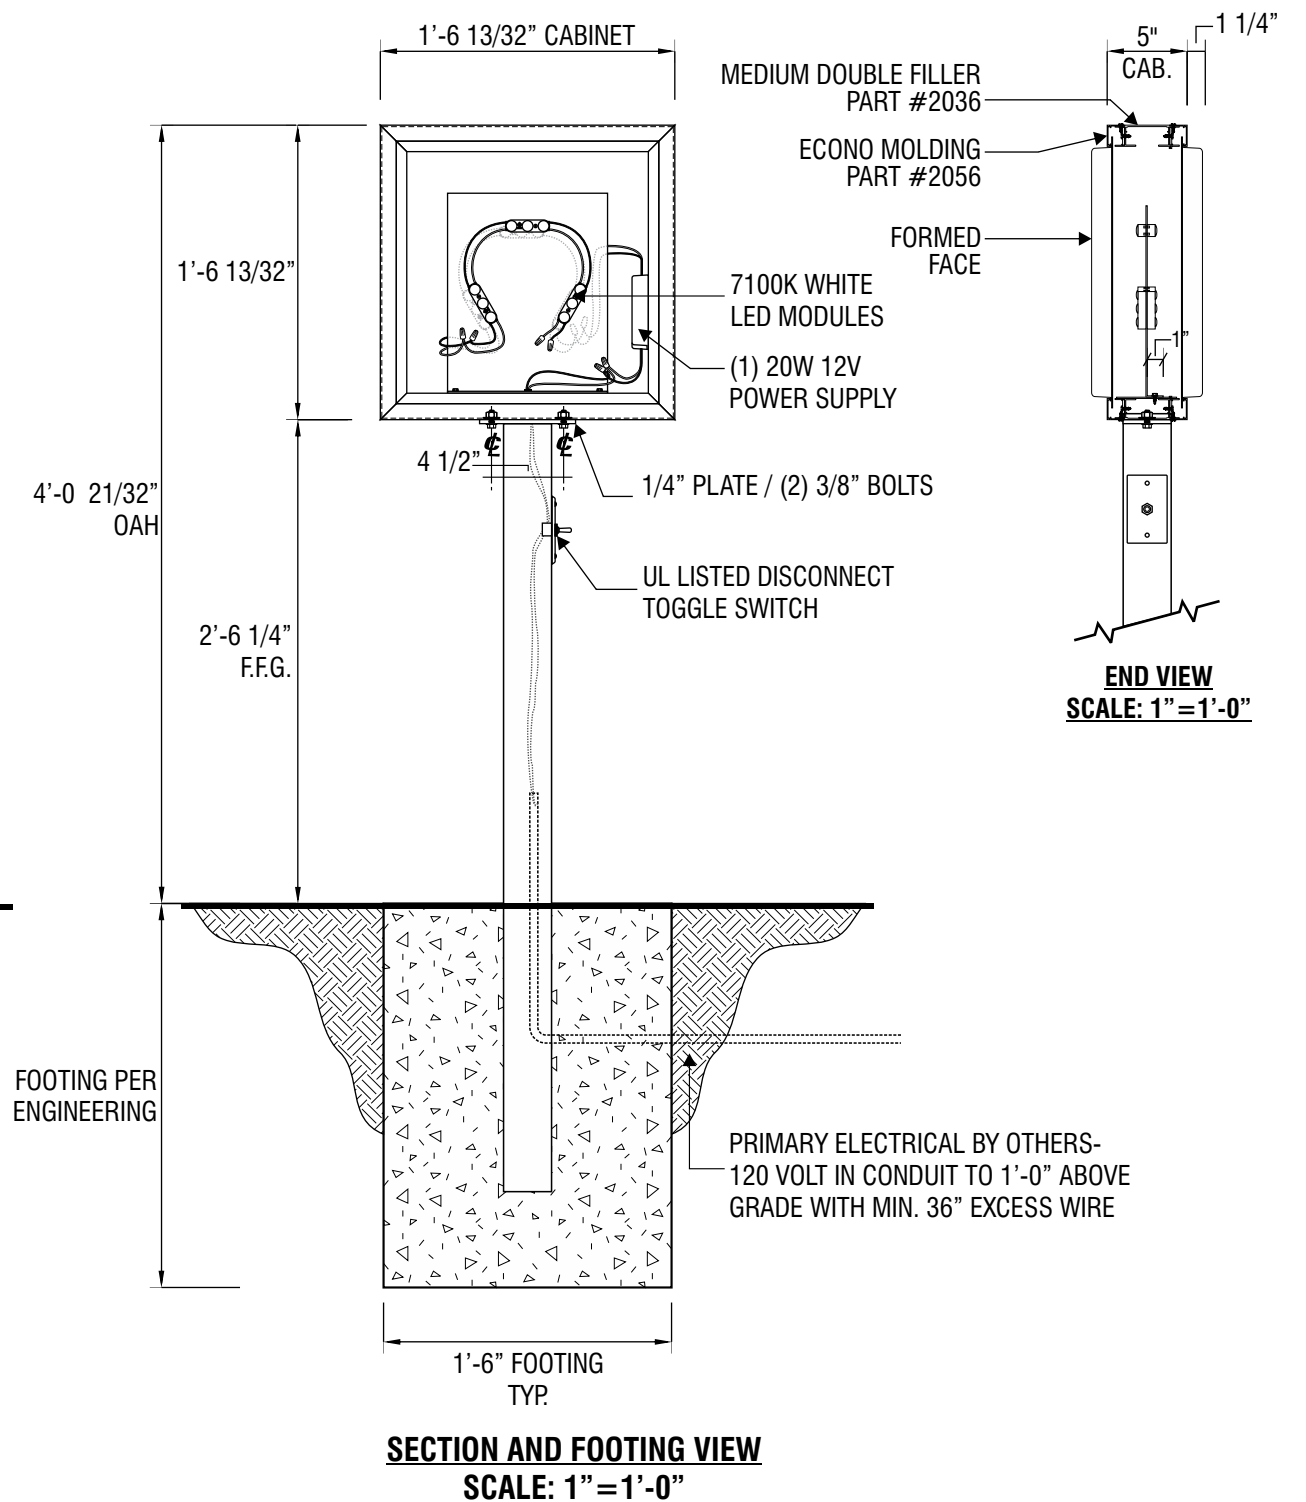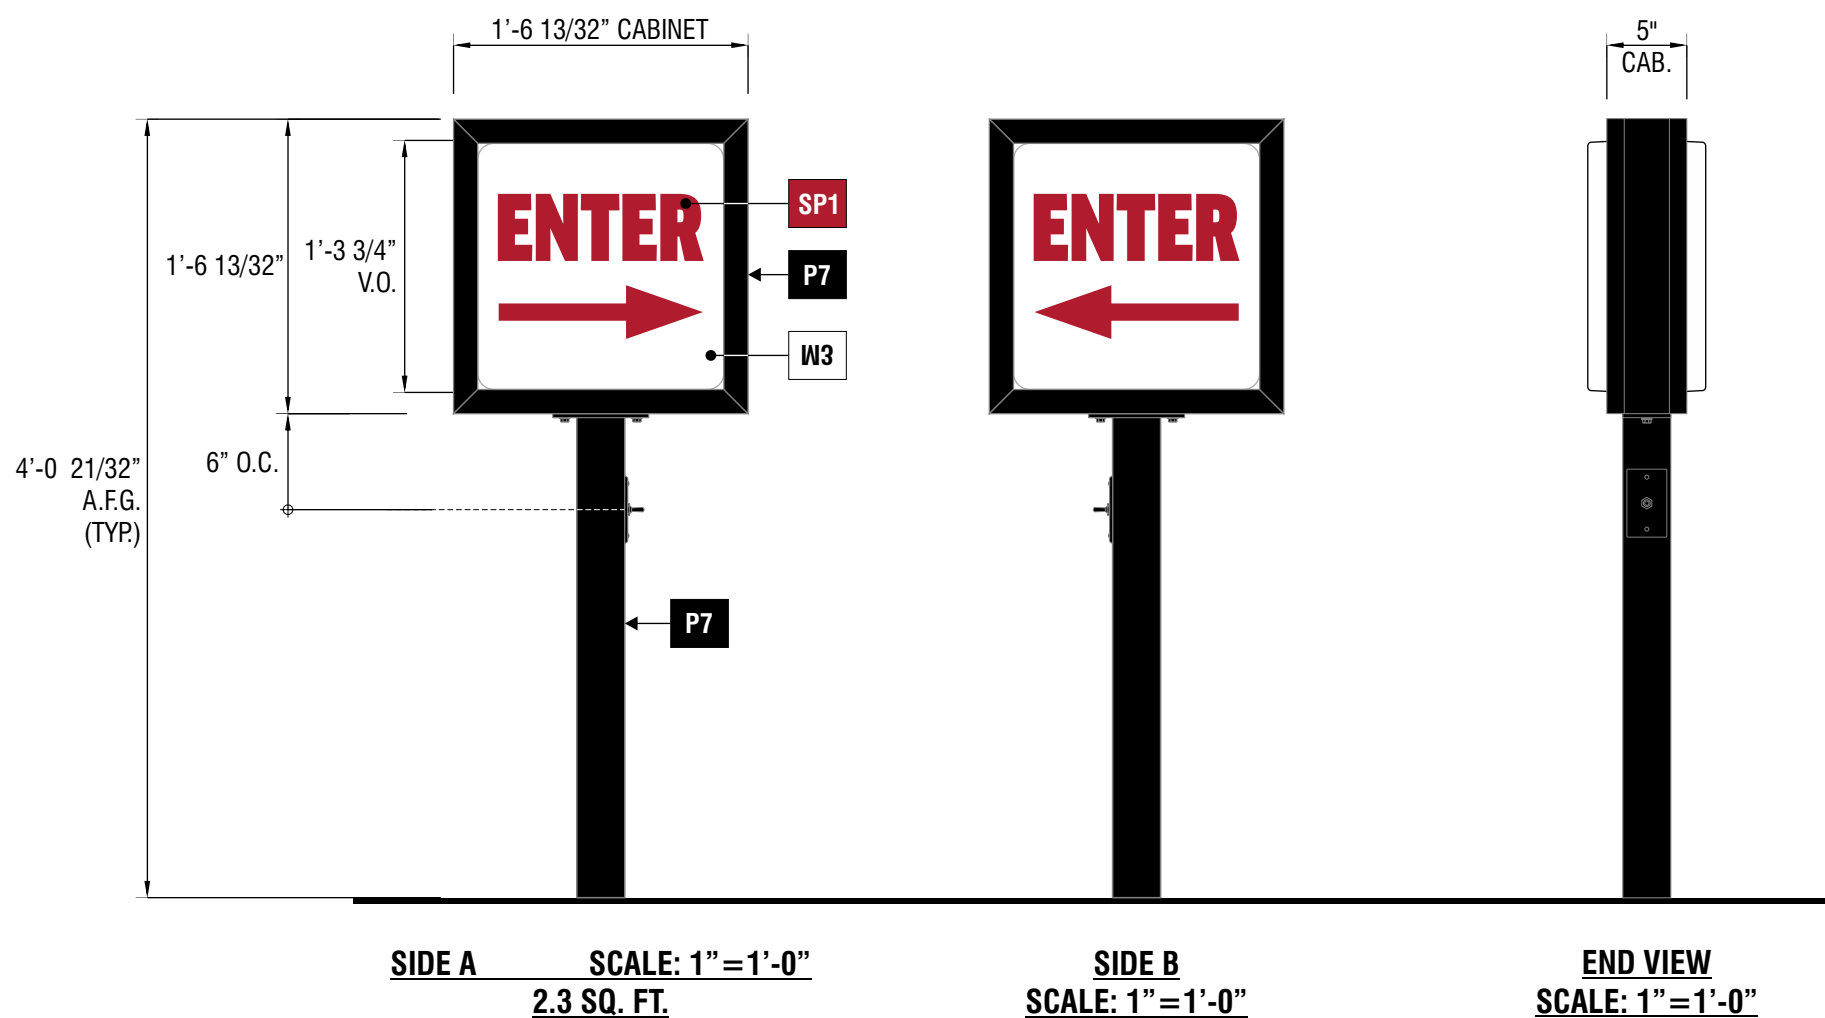

L1 L2 SIGNTYPE JITB-DIR-17x17x48-ENTER-LEFT/RIGHT

MANUFACTURE AND INSTALL TWO (2) D/F INTERNALLY ILLUMINATED DIRECTIONAL SIGN(S)
FACE: FORMED .093" WHITE POLYCARBONATE FACE WITH FIRST SURFACE SCREEN PRINTED GRAPHICS
CABINET BODY: EXTRUDED ALUMINUM - SIGNCOMP PART NO. 2036
RETAINER: EXTRUDED ALUMINUM - SIGNCOMP PART NO. 2056
POLE: 3"x3" STEEL SQUARE TUBE WITH 1/4" MOUNTING PLATE
ILLUMINATION: LED - PRINCIPAL QWIK MOD 3 7100K WHITE

- PAINT**
- P7** TO MATCH MP SV923 BLACK W/ SATIN FINISH
- MATERIALS**
- M3** .093" WHITE POLYCARBONATE
- SCREEN PRINT**
- SP1** TO MATCH PMS 187



4444 Federal Blvd San Diego, CA 92102
 (619) 527-6100 signtech.com



JACK IN THE BOX

J5499
 5133 E Washington Blvd, Commerce, CA 90040 USA

This design is the exclusive property of Signtech and cannot be reproduced in whole or in part, without their prior written approval

Sales: Bob McCarter
Project Manager: Steve Wood
Design: JMc
Engineering:

date: 7/1/25
drawing: J5499 Permit Package
revision: R1-7/8/25-JMc
project ID: JIB_5499_1

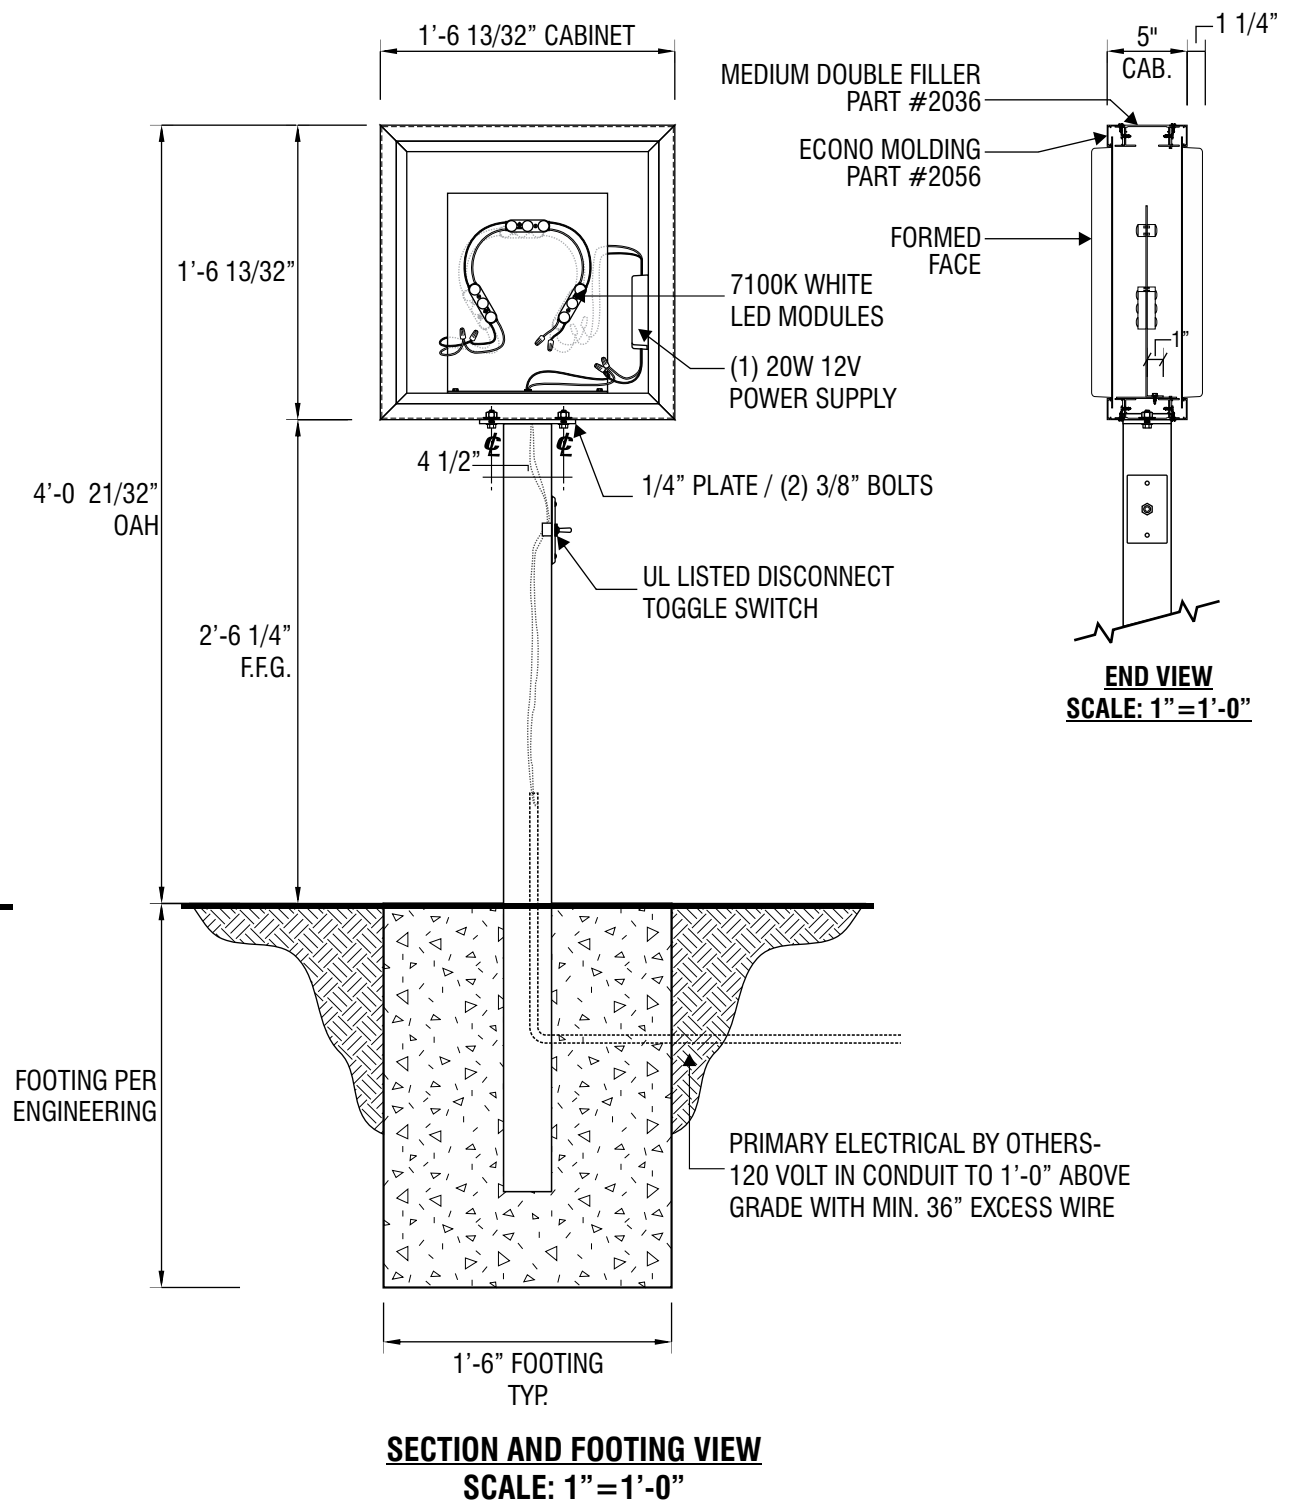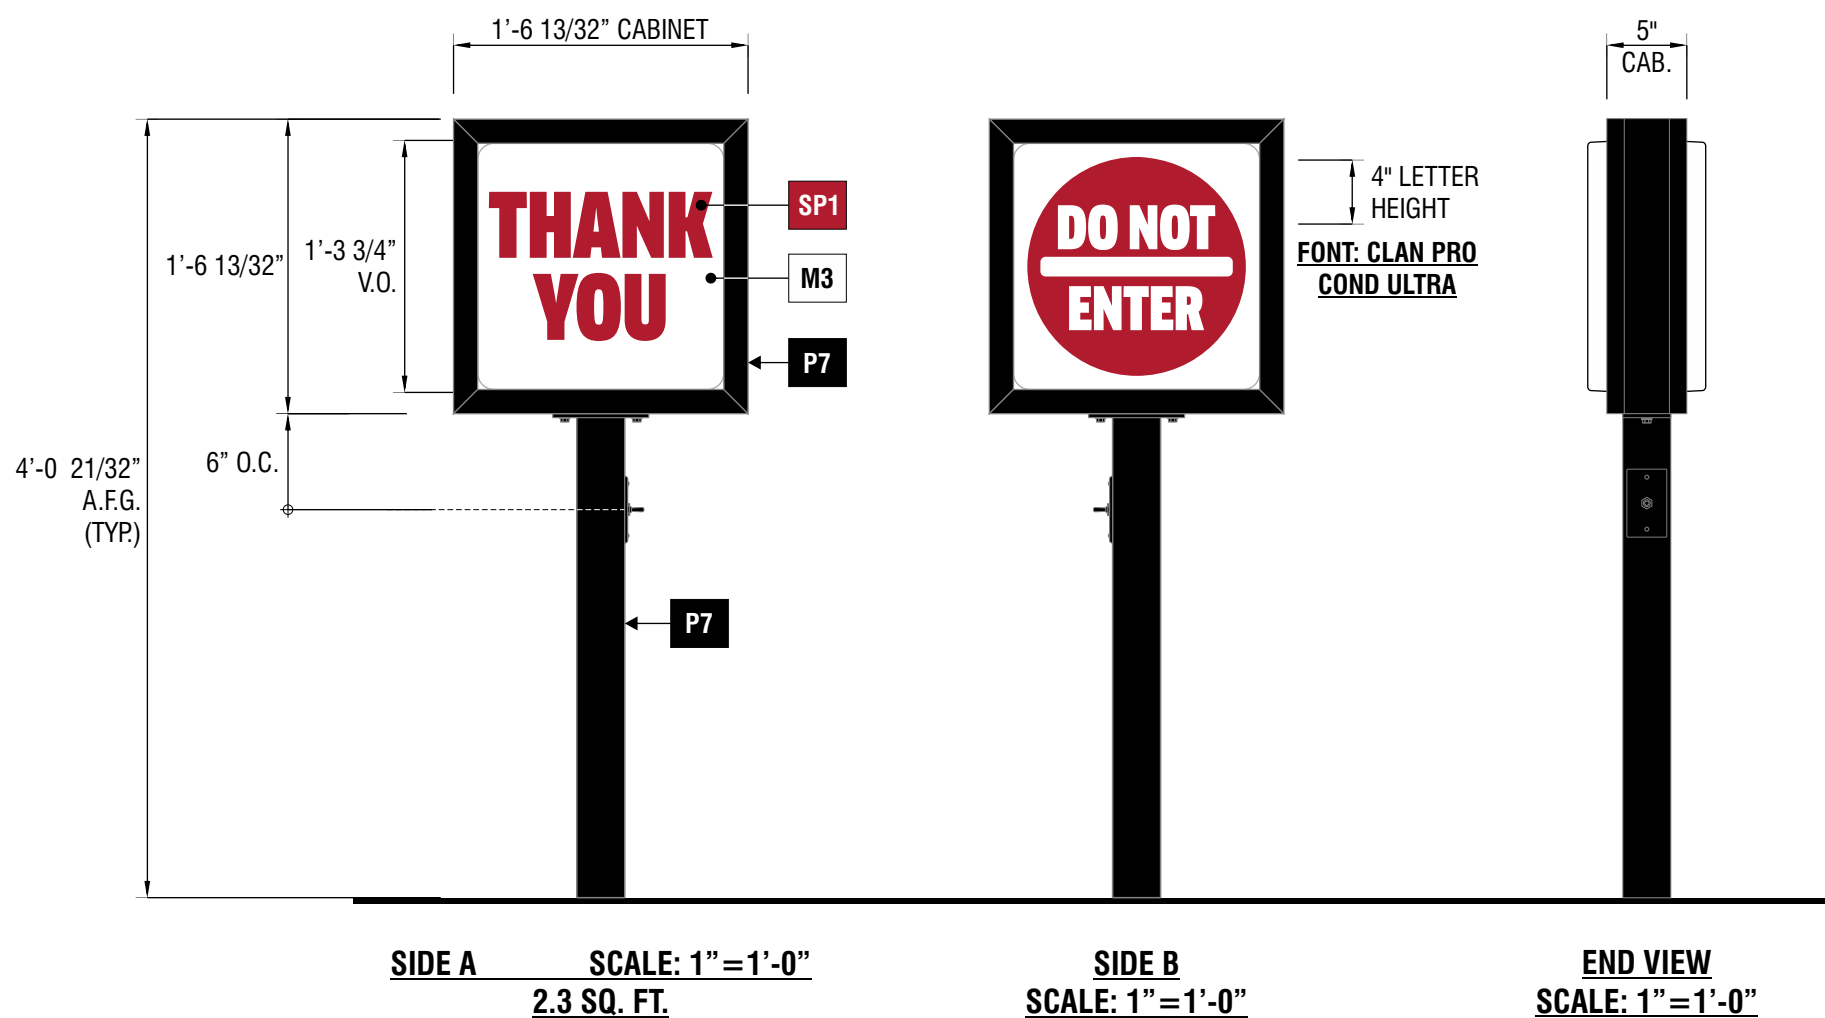

L3 SIGNTYPE JITB-DIR-17x17x48-THANK YOU-DO NOT ENTER

D/F INTERNALLY ILLUMINATED DIRECTIONAL SIGN(S)

FACE: FORMED .093" WHITE POLYCARBONATE FACE WITH FIRST SURFACE SCREEN PRINTED GRAPHICS

CABINET BODY: EXTRUDED ALUMINUM - SIGNCOMP PART NO. 2036

RETAINER: EXTRUDED ALUMINUM - SIGNCOMP PART NO. 2056

POLE: 3"x3" STEEL SQUARE TUBE WITH 1/4" MOUNTING PLATE

ILLUMINATION: LED - PRINCIPAL QWIK MOD 3 7100K WHITE

PAINT

P7 TO MATCH MP SV923 BLACK
W/ SATIN FINISH

MATERIALS

M3 .093" WHITE POLYCARBONATE

SCREEN PRINT

SP1 TO MATCH PMS 187



4444 Federal Blvd San Diego, CA 92102
(619) 527-6100 signtech.com




JACK IN THE BOX

J5499
5133 E Washington Blvd, Commerce, CA 90040 USA

This design is the exclusive property of Signtech and cannot be reproduced in whole or in part, without their prior written approval

Sales: Bob McCarter
Project Manager: Steve Wood
Design: JMc
Engineering:

date: 7/1/25
drawing: J5499 Permit Package
revision: R1-7/8/25-JMc
project ID: JIB_5499_1

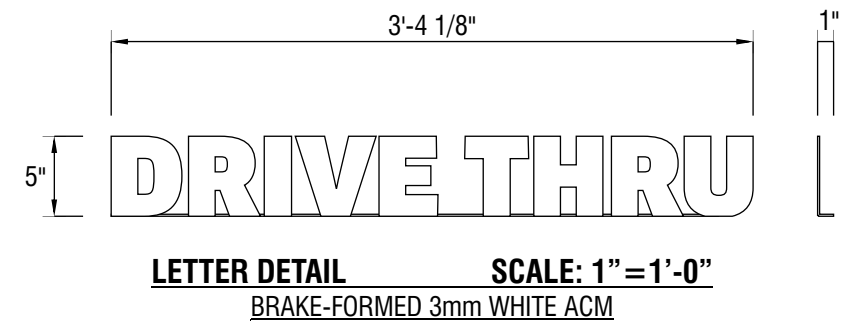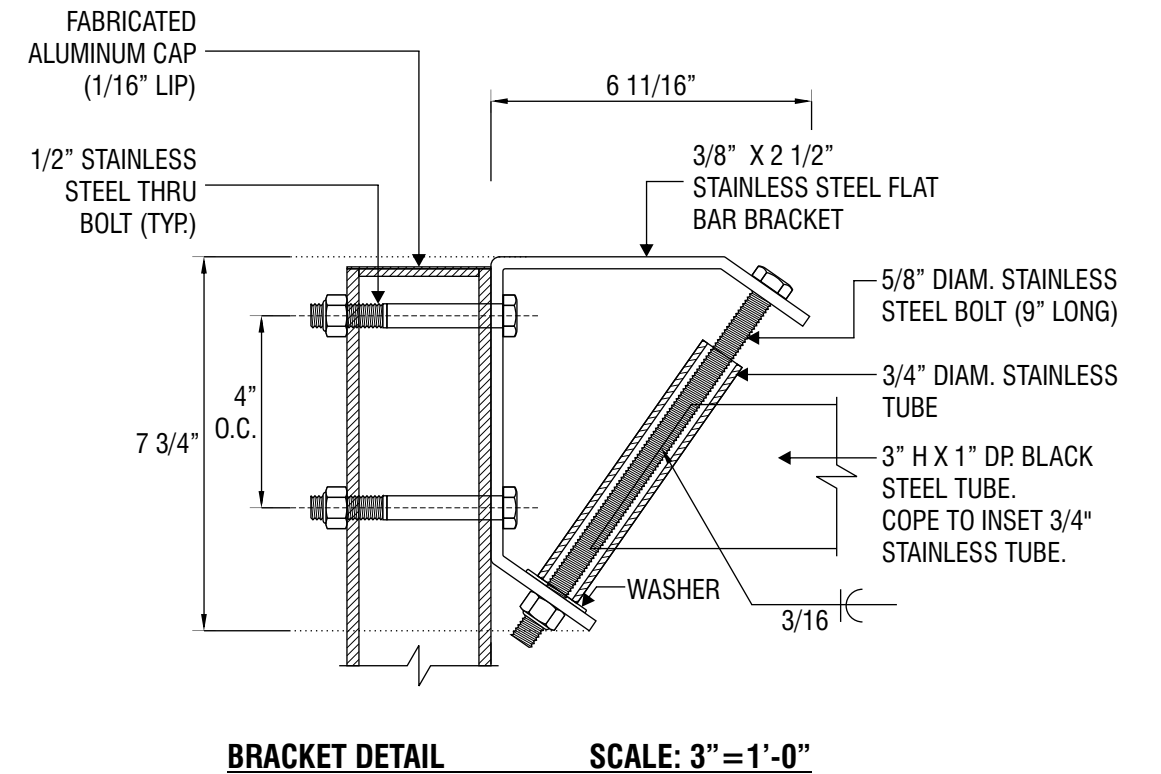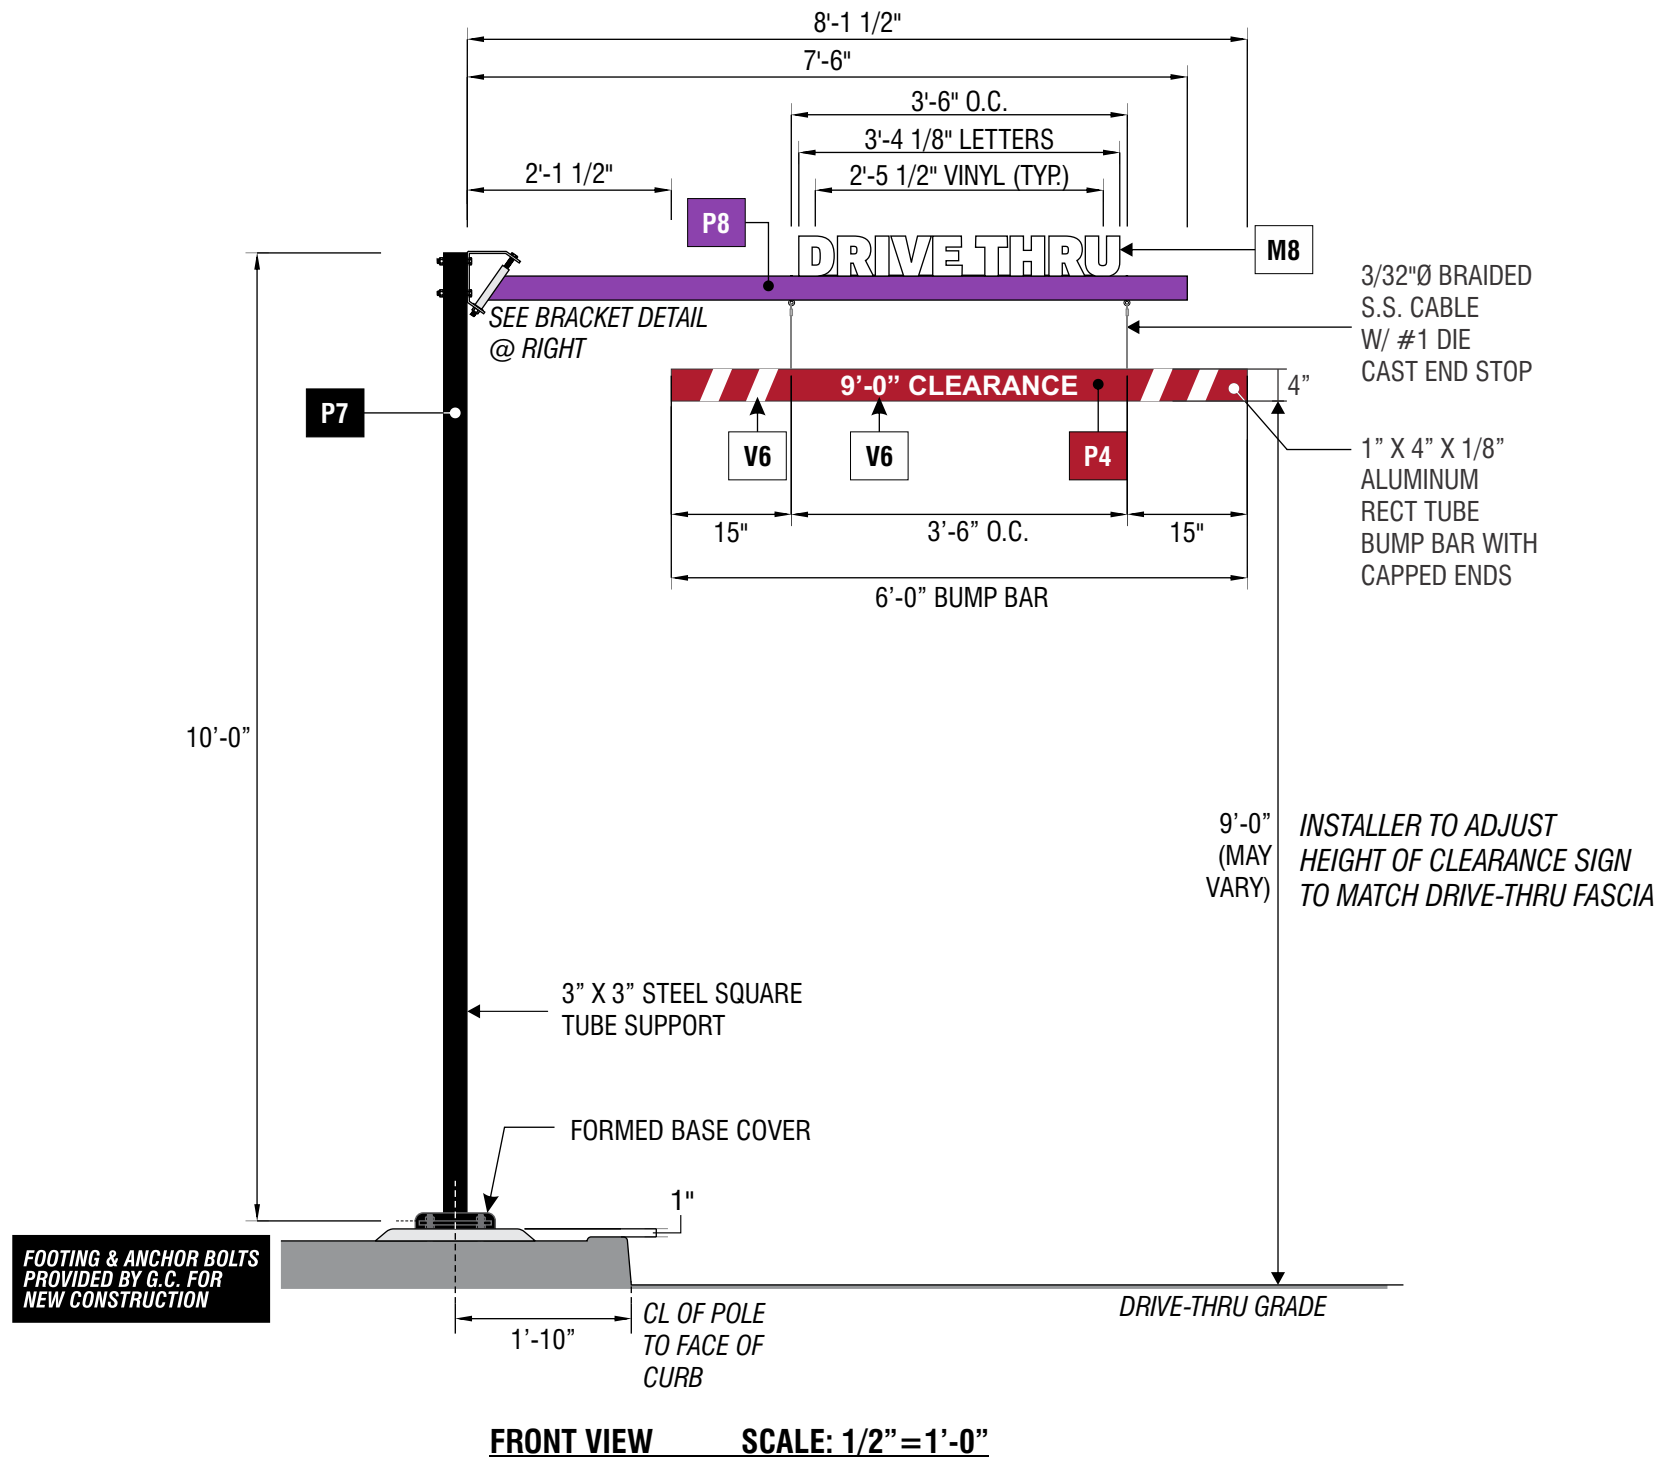

M SIGNTYPE JITB2-H-BAR-120-FCO-5

MANUFACTURE AND INSTALL ONE (1) HEIGHT DETECTOR WITH FCO LETTERS
POLE: 3"x3" STEEL SQUARE TUBE
ARM: 3"x1" STEEL RECTANGULAR TUBE
LETTERS: 3mm WHITE ACM

PAINT

P7 TO MATCH MP SV923 BLACK W/ SATIN FINISH

P4 PAINTED MATTHEWS MP 64691 'JIB RED' W/ SATIN FINISH

P8 PAINT TO MATCH SHERWIN-WILLIAMS SW6832 'IMPULSIVE PURPLE' - SATIN FINISH

VINYL

V6 3M WHITE REFLECTIVE VINYL (680-10)

MATERIAL

M8 3mm WHITE ACM



4444 Federal Blvd San Diego, CA 92102
 (619) 527-6100 signtech.com

JACK IN THE BOX
 J5499

5133 E Washington Blvd, Commerce, CA 90040 USA

This design is the exclusive property of Signtech and cannot be reproduced in whole or in part, without their prior written approval

Sales: Bob McCarter
Project Manager: Steve Wood
Design: JMc
Engineering:

date: 7/1/25
drawing: J5499 Permit Package
revision: R1-7/8/25-JMc
project ID: JIB_5499_1